


# BROWN'S RACE PARKING GARAGE

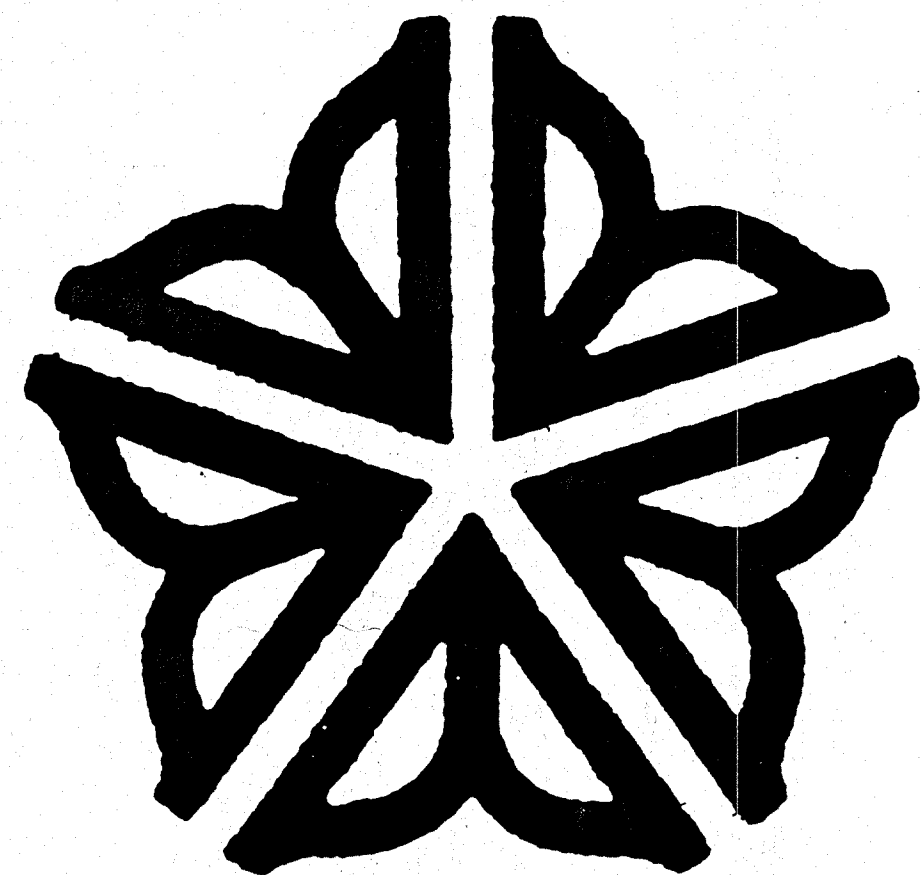

CITY OF ROCHESTER, NEW YORK  
DEPARTMENT OF ENVIRONMENTAL FACILITIES  
BUREAU OF MUNICIPAL SERVICES

**ARCHITECTS AND URBAN ENGINEERS:**

**LABELLA ASSOCIATES, P.C.**

300 State Street, Rochester, New York 14614

**MECHANICAL AND ELECTRICAL ENGINEERS:**

**ROBSON & WOESE, INC.**

555 Penbrooke Drive, Penfield, New York 14526

**ARCHITECTURAL AND URBAN DESIGN CONSULTANTS:**

**WILLIAM RAWN ASSOCIATES, ARCHITECTS**

101 Tremont Street, Boston, Massachusetts 02108

**STRUCTURAL ENGINEER AND PARKING CONSULTANT:**

**CARL WALKER ENGINEERS**

445 W. Michigan Avenue, Suite 101, Kalamazoo, Michigan 49007


B-8

BROWN  
RACE  
GARAGE


# ABBREVIATIONS

|            |                       |          |                                           |         |                        |
|------------|-----------------------|----------|-------------------------------------------|---------|------------------------|
| @          | At                    | FEC      | Fire Extinguisher Cabinet                 | O.C.    | On Center              |
| A.F.F.     | Above Finished Floor  | F.D.     | Floor Drain                               | O.D.    | Outside Dimension      |
| ALUM.      | Aluminum              | FIN.     | Finish(ed)                                | OPN.    | Opening                |
| ANOD.      | Anodized              | FLR.     | Floor                                     | PT.     | Paint(ed)              |
| ARCH.      | Architect             | FOUND.   | Foundation                                | P.TRTD. | Pressure Treated       |
| A.T.       | Acoustical Tile       | FTG.     | Footing                                   | PLYWD.  | Plywood                |
| BD.        | Board                 | GA.      | Gauge                                     | Q.T.    | Quarry Tile            |
| BLDG.      | Building              | GALV.    | Galvanize(d)                              |         |                        |
| BLKG.      | Blocking              | G.C.     | General Contractor                        |         |                        |
| B.O.       | Bottom of             | GL.      | Glass                                     |         |                        |
|            |                       | GWB      | Gypsum Wall Board                         |         |                        |
| C.B.       | Catch Basin           | HC.      | Handicap(ped)                             | R.      | Radius                 |
| C.I.       | Cast Iron             | H.M.     | Hollow Metal                              | RBT     | Rubber Floor Tile      |
| CL.        | Center Line           | HORIZ.   | Horizontal                                | REF.    | Reference              |
| CLG.       | Ceiling               | HT.      | Height                                    | REINF.  | Reinforce(ed)Xing      |
| CLR.       | Clear                 | H.V.A.C. | Heating, Ventilating and Air Conditioning | RM.     | Room                   |
| C.M.T.     | Ceramic Mosaic Tile   |          |                                           | R.O.    | Rough Opening          |
| C.M.U.     | Concrete Masonry Unit |          |                                           | R.O.B.  | Run to Bank (gravel)   |
| COL.       | Column                | I.D.     | Inside Dimension                          | SC      | Solid Core Wood Door   |
| CONC.      | Concrete              | INSUL.   | Insulation                                | SCHED.  | Schedule               |
| CONT.      | Continuous            | INT.     | Interior                                  | SHT.    | Sheet                  |
| CPT.       | Carpet                |          |                                           | SIM.    | Similar                |
| C.S.P.     | Corrugated Steel Pipe |          |                                           | SPEC.   | Specification          |
| C.T.       | Ceramic Tile          | JT.      | Joint(s)                                  | S.S.    | Stainless Steel        |
|            |                       |          |                                           | STD.    | Standard               |
| D.F.       | Drinking Fountain     | LAM.     | Laminate(d)                               | STL.    | Steel                  |
| DIA.       | Diameter              | LB(#)    | Pound                                     | SUSP.   | Suspension(ed)         |
| DN.        | Down                  | LL.H.    | Long Leg Horizontal                       | T&G     | Tounge & Groove        |
| DW.        | Drywall               | LL.V.    | Long Leg Vertical                         | TEMPD.  | Tempered               |
| DWG.(S)    | Drawing(s)            | L.P.     | Light Pole                                | T.O.    | Top Of                 |
|            |                       |          |                                           | TYP.    | Typical                |
| EA.        | Each                  | MFR.     | Manufacture(r)                            | U.N.O.  | Unless Noted Otherwise |
| E.F.       | Exhaust Fan           | MAX.     | Maximum                                   |         |                        |
| ELEC.      | Electrical            | M.D.O.   | Medium Density Overlay                    | VAR.    | Varies                 |
| EL.        | Elevator              | MECH.    | Mechanical                                | V.C.    | Vinyl Cove             |
| ELEV.      | Engineer              | MTL.     | Metal                                     | VERT.   | Vertical               |
| ENGR/ENG   | Engineer              | MHL.     | Manhole                                   | V.L.F.  | Verify in Field        |
| EPX        | Epoxy                 | MIN.     | Minimum                                   | V.T.    | Vinyl Tile             |
| EQ.        | Equal                 | MISC.    | Miscellaneous                             | V.W.C.  | Vinyl Wall Covering    |
| E.W.       | Each Way              | M.O.     | Masonry Opening                           |         |                        |
| EXIST (ex) | Existing              | N.I.C.   | Not in Contract                           | W.      | With                   |
| EXP.       | Expansion             | NO.      | Number (#)                                | WO.     | Without                |
| EXT.       | Exterior              | NOM.     | Nominal                                   | WD.     | Wood                   |
|            |                       | N.T.S.   | Not to Scale                              | W.W.M.  | Welded Wire Mesh       |

# CONVENTIONS

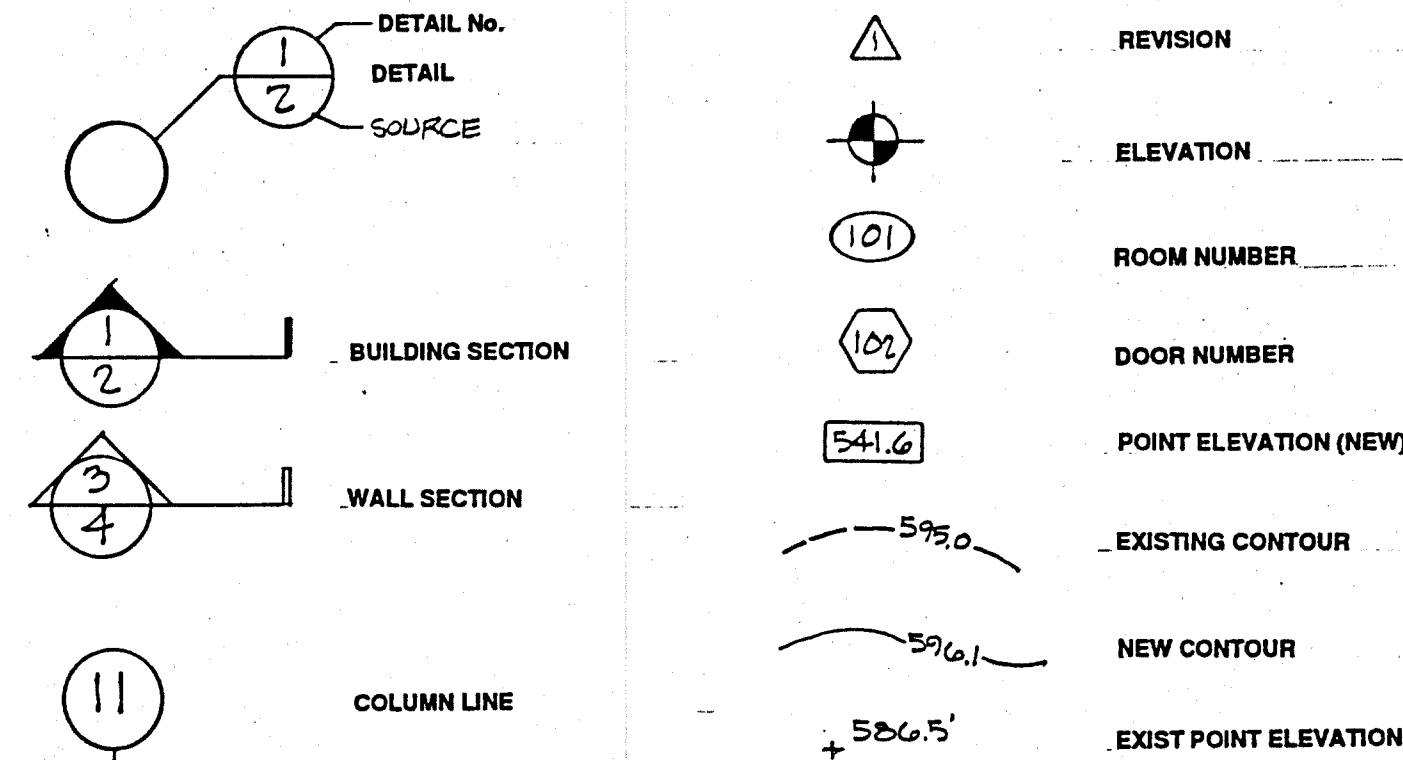


# MATERIALS SYMBOLS

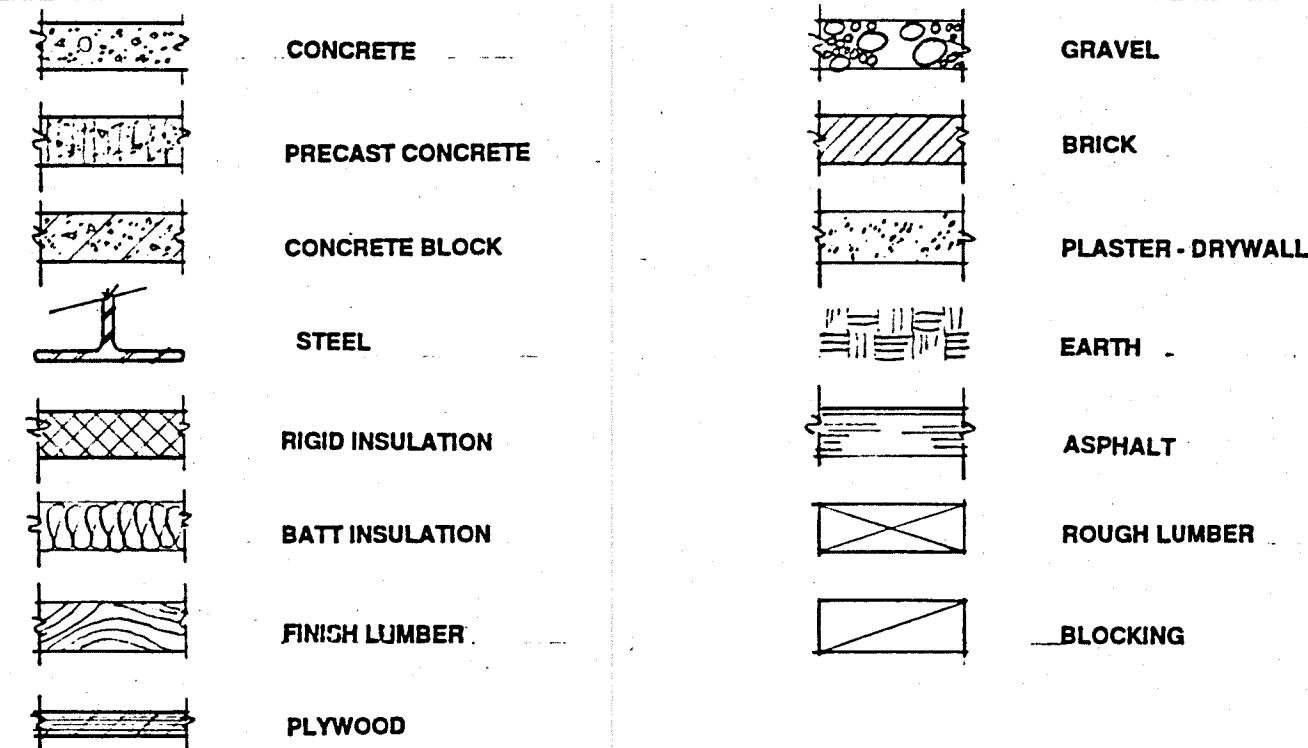

# LIST OF DRAWINGS

|        |                                                        |       |                                                            |
|--------|--------------------------------------------------------|-------|------------------------------------------------------------|
| A.0    | SYMBOLS AND ABBREVIATIONS                              | S4.2  | PIT SCHEDULE & DETAILS                                     |
| A.1    | SITE PLAN                                              | S4.3  | PIT DETAILS                                                |
| A.2.1  | GROUND LEVEL PLAN                                      | S5.1  | SEALANT DETAILS                                            |
| A.2.2  | LEVEL 2 FLOOR PLAN                                     | S5.2  | DETAILS                                                    |
| A.2.3  | LEVEL 3 FLOOR PLAN                                     | S5.3  | DETAILS                                                    |
| A.2.4  | LEVEL 4 FLOOR PLAN                                     | S5.4  | DETAILS                                                    |
| A.2.5  | LEVEL 5 FLOOR PLAN                                     | S6.1  | STAIRTOWER 1 FOUNDATIONS                                   |
| A.2.6  | LEVEL 6 FLOOR PLAN                                     | S6.2  | STAIRTOWER 1 ELEVATOR & COLUMN FOUNDATIONS MECHANICAL ROOM |
| A.2.7  | LEVEL 7 FLOOR PLAN                                     | S6.3  | STAIRTOWER 1 ELEVATOR                                      |
| A.2.8  | LEVEL 7 PLAN ALTERNATE NO.1                            | S6.4  | STAIRTOWER 1 COLUMN TRUSSES                                |
| A.3.1  | SOUTH ELEVATION                                        | S6.5  | STAIRTOWER 1 COLUMN TRUSS DETAILS                          |
| A.3.2  | WEST ELEVATION                                         | S6.6  | STAIRTOWER 1 C.I.P. LANDINGS                               |
| A.3.3  | NORTH ELEVATION                                        | S6.7  | STAIRTOWER 1 PRECAST CONCRETE                              |
| A.3.4  | EAST ELEVATION                                         | S6.8  | STAIRTOWER 1 HIGH ROOF                                     |
| A.4.1  | CROSS SECTION                                          | S6.9  | STAIRTOWERS 2 & 3 PYRAMID FOUNDATIONS                      |
| A.4.2  | CROSS SECTION                                          | S6.10 | STAIRTOWERS 2 & 3 PYRAMID GENERAL VIEW                     |
| A.4.3  | SCHEDULES AND DETAILS                                  | S6.11 | STAIRTOWERS 2 & 3 PYRAMID DETAILS                          |
| A.4.4  | HANDRAILS & GUARDRAILS                                 | S6.12 | STAIRTOWER 3 ELEVATOR                                      |
| A.4.5  | STOREFRONT DETAILS                                     | S6.13 | STAIRTOWER 2 & 3 TRUSS GENERAL VIEW                        |
| A.4.6  | ROOFING & STOREFRONT DETAILS                           | S6.14 | STAIRTOWER 3 & 3 TRUSS DETAILS                             |
| A.4.7  | SOUTH ELEVATION - COMMERCIAL STREET - PRECAST BASE BID | S6.15 | STAIRTOWER 4 1ST AND 2ND LEVELS                            |
| A.4.8  | WEST ELEVATION - STATE STREET - PRECAST BASE BID       | S6.16 | STAIRTOWER 4 ENLARGED PLANS & DETAILS                      |
| A.4.9  | NORTH ELEVATION - PASSAGEWAY - PRECAST BASE BID        | S7.1  | PRECAST CONNECTION DETAILS                                 |
| A.4.10 | EAST ELEVATION - MILL STREET - PRECAST BASE BID        | S7.2  | DETAILS                                                    |
| A.4.11 | PRECAST - ALTERNATE BID - NO. 3                        | F1.1  | GROUND LEVEL PLAN - FUNCTIONAL                             |
| A.4.12 | PRECAST CONFIGURATION DETAILS AND ISOMETRICS           | F1.2  | LEVEL 2 PLAN - FUNCTIONAL                                  |
| A.4.13 | WEST ELEVATION - STATE STREET - BUILDING RAILS         | F1.3  | LEVEL 3 PLAN - FUNCTIONAL                                  |
| A.4.14 | EAST & NORTH ELEVATIONS - BUILDING RAILS               | F1.4  | LEVEL 4 PLAN - FUNCTIONAL                                  |
| A.4.15 | BUILDING RAILS DETAILS                                 | F1.5  | LEVEL 5 PLAN - FUNCTIONAL                                  |
| A5.1   | GROUND LEVEL AREA PLANS                                | F1.6  | LEVEL 6 PLAN - FUNCTIONAL                                  |
| A5.2   | GROUND LEVEL AREA ELEVATIONS                           | F1.7  | LEVEL 7 PLAN - FUNCTIONAL                                  |
| A5.3   | GROUND LEVEL AREA DETAILS                              | F1.8  | SIGN SCHEDULE AND DETAILS                                  |
| A6.1   | STAIRS 1 PLANS                                         | F1.9  | SIGNAGE DETAILS                                            |
| A6.2   | STAIRS 1 PLANS                                         | F1.10 | SIGN MOUNTING DETAILS                                      |
| A6.3   | STAIRS 1 DIMENSIONS                                    | F1.11 | SIGNAGE DETAILS AND ELEVATIONS                             |
| A6.4   | STAIRS 1 DIMENSIONS                                    | F1.12 | SIGNAGE DETAILS                                            |
| A6.5   | STAIRS 1 ELEVATOR                                      | E.1   | GROUND LEVEL PLAN                                          |
| A6.6   | STAIRS 1 COLUMNS                                       | E.2   | LEVEL 2 PLAN                                               |
| A6.7   | STAIRS 1 DETAILS                                       | E.3   | TYPICAL LEVEL PLAN - 3 THRU 8                              |
| A6.8   | STAIRS 1 DRAINAGE                                      | E.4   | LEVEL 7 PLAN                                               |
| A6.9   | STAIRS 1 ROOF DETAILS                                  | E.5   | PARTIAL FLOOR PLANS                                        |
| A6.10  | STAIRS 1 STOREFRONT PLANS                              | E.6   | PARTIAL FLOOR PLANS                                        |
| A6.11  | STAIRS 1 STOREFRONT PLANS                              | E.7   | POWER ONE - LINE DIAGRAM & SCHEDULES                       |
| A6.12  | STAIRS 1 STOREFRONT ELEVATIONS                         | E.8   | SIGNAL ONE - LINE DIAGRAMS                                 |
| A7.1   | STAIRS 2 PLANS                                         | E.9   | EQUIPMENT SCHEDULES & DETAILS                              |
| A7.2   | STAIRS 2 PLANS                                         | E.10  | LOW VOLTAGE LIGHTING CONTROL DIAGRAMS                      |
| A7.3   | STAIRS 2 SECTION & ELEVATION                           | E.11  | LIGHTING CONTROL DETAILS & DIAGRAMS                        |
| A7.4   | STAIRS 2 SECTION                                       | E.12  | SYMBOLS & MISCELLANEOUS DETAILS                            |
| A7.5   | STAIRS 2 DETAILS                                       |       |                                                            |
| A8.1   | STAIRS 3 PLANS                                         | H.1   | PARTIAL FLOOR PLANS                                        |
| A8.2   | STAIRS 3 PLANS                                         | H.2   | PARTIAL FLOOR PLANS                                        |
| A8.3   | STAIRS 3 SECTION & ELEVATION                           | H.3   | SYMBOLS, SCHEDULES & DETAILS                               |
| A8.4   | STAIRS 3 SECTION                                       |       |                                                            |
| A8.5   | STAIRS 3 ELEVATOR                                      | P.1   | SITE PLAN                                                  |
| A9.1   | STAIRS 4 PLAN                                          | P.2   | FOUNDATION PLAN                                            |
| A9.2   | STAIRS 4 SECTIONS & DETAILS                            | P.3   | GROUND LEVEL PLAN                                          |
|        |                                                        | P.4   | LEVEL 2 PLAN                                               |
|        |                                                        | P.5   | TYPICAL LEVEL PLAN                                         |
| S1.1   | GENERAL NOTES                                          | P.6   | LEVEL 7 PLAN                                               |
| S1.2   | TYPICAL DETAILS                                        | P.7   | PARTIAL FLOOR PLANS                                        |
| S2.0   | PARKING STRUCTURE FOUNDATION PLANS                     | P.8   | PARTIAL FLOOR PLANS                                        |
| S2.1   | GROUND LEVEL PLAN - STRUCTURAL                         | P.9   | SYMBOLS SCHEDULES & DETAILS                                |
| S2.2   | LEVEL 2 PLAN - STRUCTURAL                              |       |                                                            |
| S2.3   | LEVEL 3 THRU LEVEL 6 PLANS STRUCTURAL                  |       |                                                            |
| S2.4   | LEVEL 7 PLAN - STRUCTURAL                              |       |                                                            |
| S3.1   | PARKING STRUCTURE FOUNDATION DETAILS                   |       |                                                            |
| S4.1   | COLUMN SCHEDULE & DETAILS                              |       |                                                            |

# LOCATION MAP:

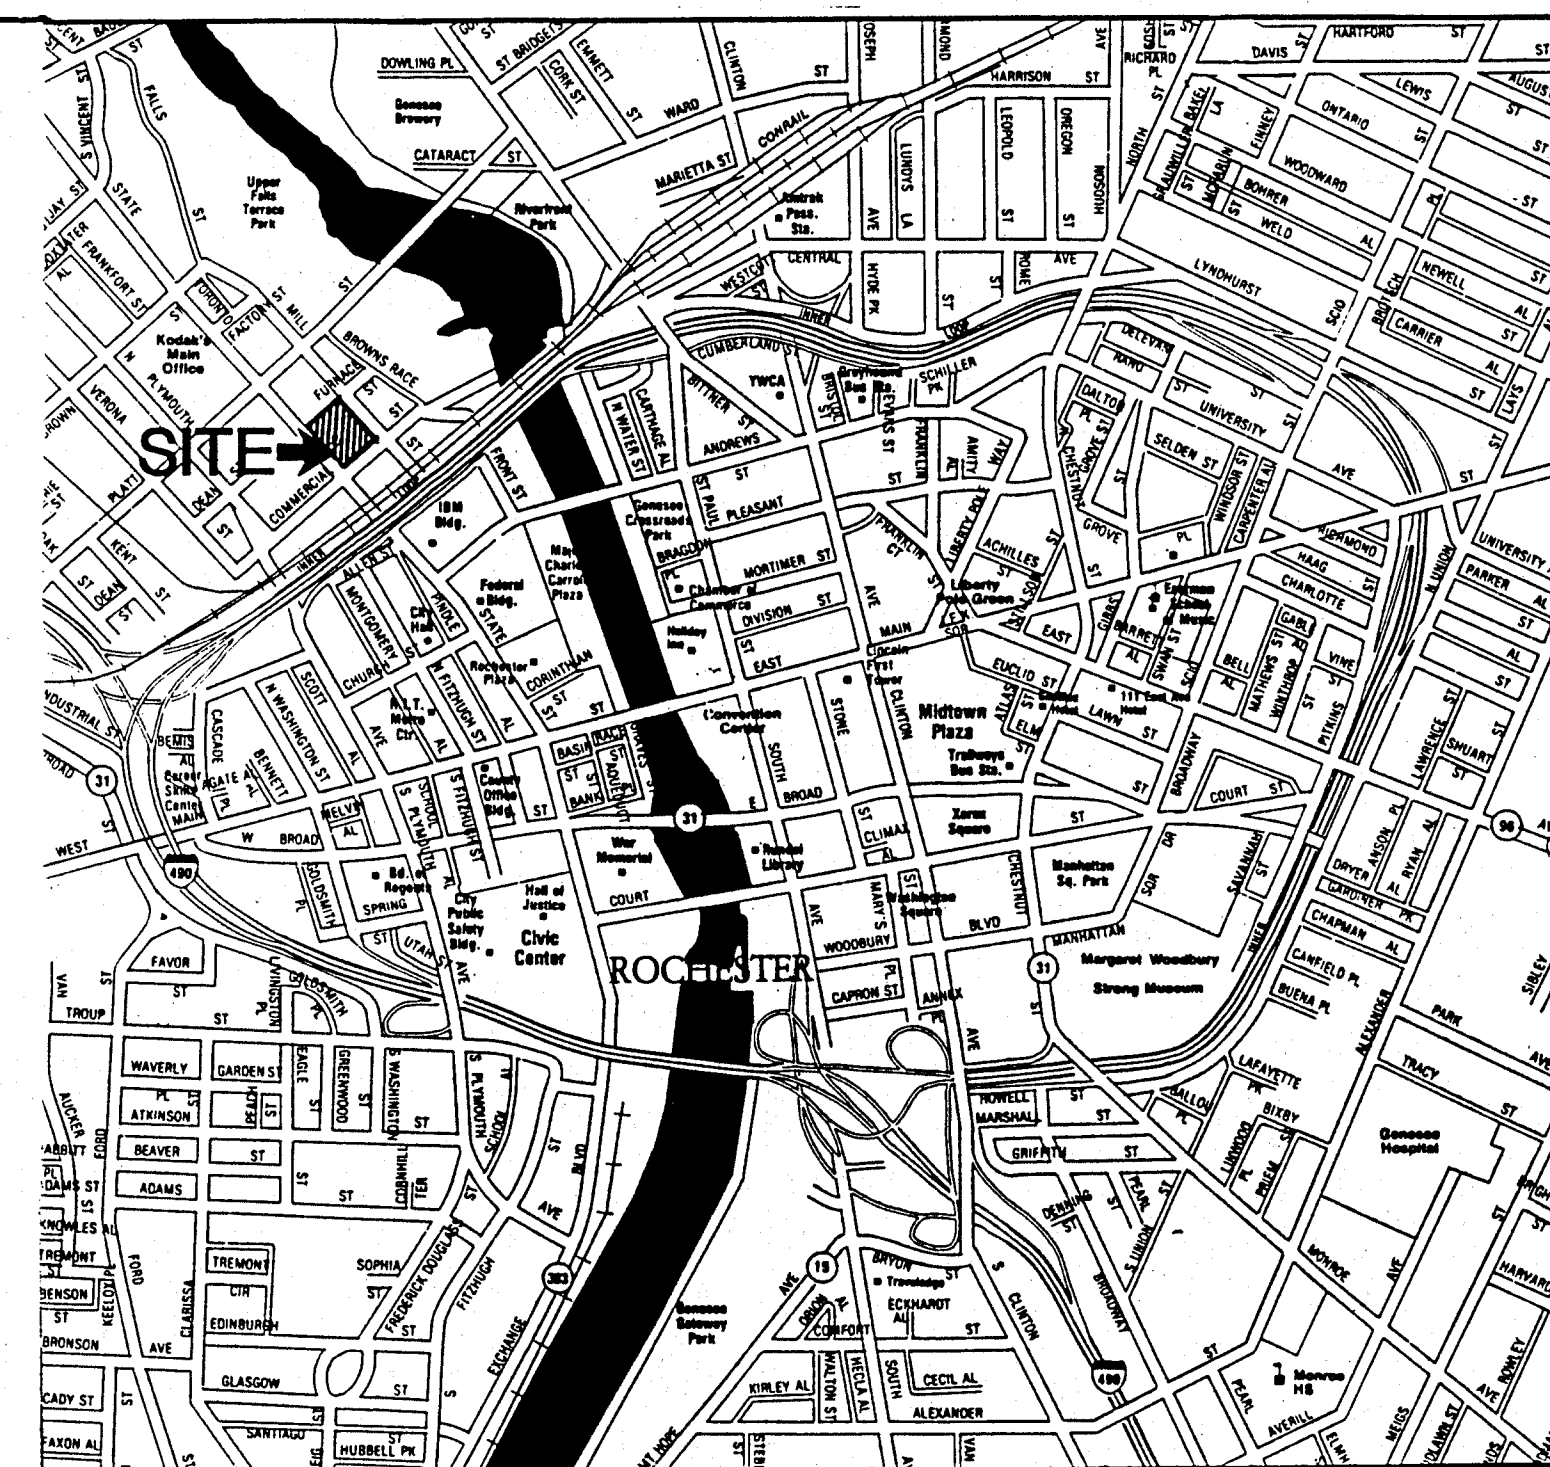


It is a violation of the New York Education Law, Article 145 Sec. 2209, for any person, unless he is acting under the direction of a licensed professional engineer or land surveyor, to alter an item in any way. If an item bearing the seal of an engineer or land surveyor is altered, the altering engineer or land surveyor shall affix to the item his seal and the notation "altered by" followed by his signature and the date of such alteration, and a specific description of the alteration.

Copyright © 1992

**LABELLA**  
Engineering, Architecture and Surveying

LaBella Associates, P.C.  
300 STATE ST.  
ROCHESTER, N.Y. 14614  
(716) 454-6110

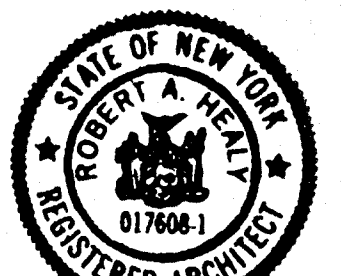

BY *Robert A. Hella*  
LIC. NO. 017608-1 DATE 8-12-92

CLIENT  
**CITY OF ROCHESTER  
NEW YORK**  
  
**DEPARTMENT OF  
ENVIRONMENTAL  
SERVICES**  
  
**BUREAU OF  
MUNICIPAL FACILITIES**


PROJECT NAME  
  
**BROWN'S RACE  
PARKING GARAGE**  
  
**CITY OF ROCHESTER  
NEW YORK**

DRAWING TITLE  
  
**SYMBOLS  
&  
ABBREVIATIONS**

DESIGNED BY:  
DRAWN BY:  
CHECKED BY: LEB  
APPROVED BY: RAH  
FIELD BOOKS: PROJECT NO. 91416  
DWG. NO. A-0  
SCALE: —  
DATE: 12-15-92  
FILE NO.: SHEET OF

1. Aerial and below ground utilities are not shown on this plan. Refer to other plans for this information. Locations shown on the plans are approximate and are not guaranteed. The Contractor alone shall be responsible for determining the exact horizontal and vertical location of all structures and utilities in the path of, closely parallel to, and below the elevation of the proposed work.
2. The Owners of the various utilities will field locate and mark the approximate location of their facilities. It is the Contractor's responsibility to notify the various utility owners in ample time for them to relocate their facilities. (UFPO Stakeout number is 1-800-962-7962).
3. The Contractor shall perform work required to verify all existing invert elevations of existing utilities prior to the start of construction at no additional cost to the Owner. Gravity flows shall be maintained for all existing storm and sanitary facilities.
4. The Contractor shall adjust existing valve boxes to grade. Frames and valve boxes damaged by the Contractor during excavation or adjustment shall be replaced by him at no additional cost to the Owner.
5. Highway drainage shall be maintained throughout the period of construction.
6. Safe and continuous through traffic and ingress and egress for private driveways, service roads, and public streets shall be maintained at all times-throughout the period of construction. Two-way traffic shall be maintained at all times throughout the period of construction.
7. The Contractor shall meet the requirements of the City of Rochester for all construction signs, barriers, temporary lane closures and detours used on this project.
8. All signs within the contract limits are to be maintained and relocated by the Contractor, the cost of which shall be paid by the Contractor.
9. Property and right-of-way lines shown on the plans are taken from records and are not guaranteed.
10. The Contractor shall locate and preserve all survey monuments including property pins and markers. Those disturbed by construction activities shall be replaced by a licensed Land Surveyor. All costs shall be borne by the Contractor.
11. The existing pavement and concrete sidewalks shall be saw cut prior to any excavation. The cost for saw cutting shall be included in the price bid for the various bid items.
12. The existing granite curb shall be reset prior to construction of the new sidewalk. Existing granite in lengths less than 3 feet shall be replaced with new granite of equal dimensions to the existing material.


1. Remove existing granite curb to backside of concrete sidewalk.
2. Remove existing parking meter and return to City of Rochester. Cut existing meter pipe stand to grade and fill complete with concrete. Refer to 6.
3. Remove existing trees, granite planter and concrete service walks, typ.
4. Remove existing electrical service, including panel box and pole.
5. Remove existing building foundations. Note: Refer to parking structure foundation plans and details for excavation and backfill requirements (typical).
6. Remove existing lighting including poles, pole bases and service wire and conduit.
7. Remove existing asphalt parking lot. Refer to note 5.
8. Existing building to be demolished. Refer to specification. Refer to note 5.
9. Remove existing tree and cast iron planter grate. Return grate to City of Rochester.
10. Remove existing driveway cuts.
11. Remove existing concrete retaining wall. Refer to note 5.

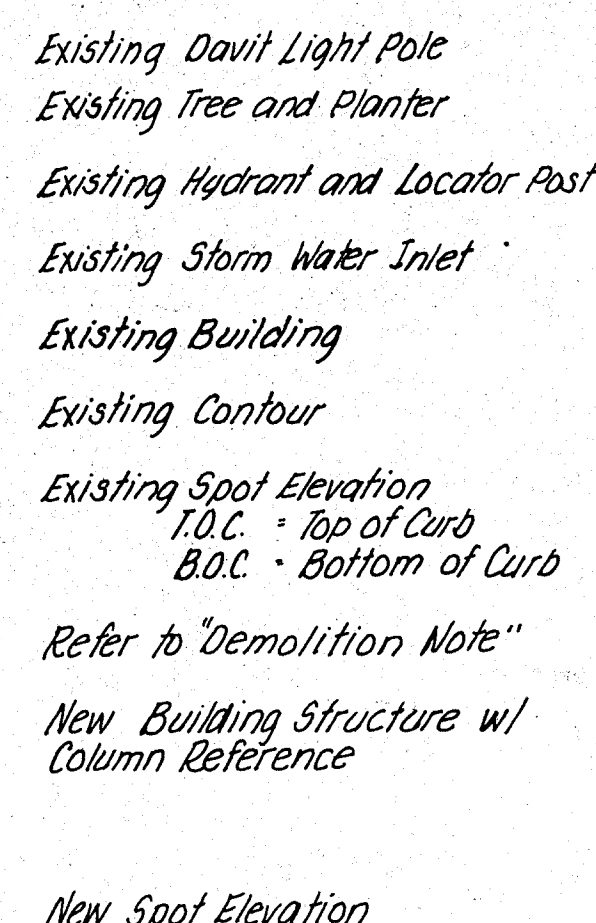

It is a violation of the New York Education Law, Article 145 Sec. 7209, for any person, unless he is acting under the direction of a licensed professional engineer or land surveyor, to alter an item in any way. If an item bearing the seal of an engineer or land surveyor is altered, the altering engineer or land surveyor shall affix to the item his seal and the notation "altered by" followed by his signature and the date of such alteration, and a specific description of the alteration.

**LABELLA**  
Engineering, Architecture and Surveying

**LaBella Associates, P.C.**  
300 STATE ST.  
ROCHESTER, N.Y. 14614  
(716) 454-6110

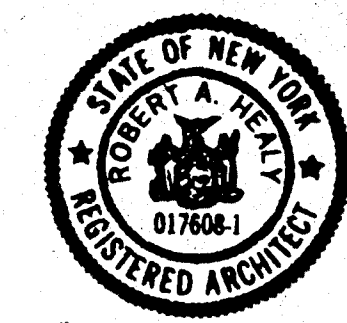

BY [Signature]  
LIC. NO. 017608-1 DATE: 8.12.92

**CLIENT**

**CITY OF ROCHESTER  
NEW YORK**

**DEPARTMENT OF  
ENVIRONMENTAL  
SERVICES**

**BUREAU OF  
MUNICIPAL FACILITIES**

PROJECT NAME

**BROWN'S RACE  
PARKING GARAGE**



**CITY OF ROCHESTER  
NEW YORK**

**DRAWING TITLE**

**SITE PLAN**

|                 |             |
|-----------------|-------------|
| DESIGNED BY:    | LEB         |
| DRAWN BY:       | ALP         |
| CHECKED BY:     | LEB         |
| APPROVED BY:    | RAH         |
| FIELD BOOKS     | PROJECT NO. |
|                 | 91416       |
| SCALE: 1"=20'   | DWG. NO.    |
| DATE: 12 AUG 92 | <b>A-1</b>  |
| FILE NO.        | SHEET OF    |



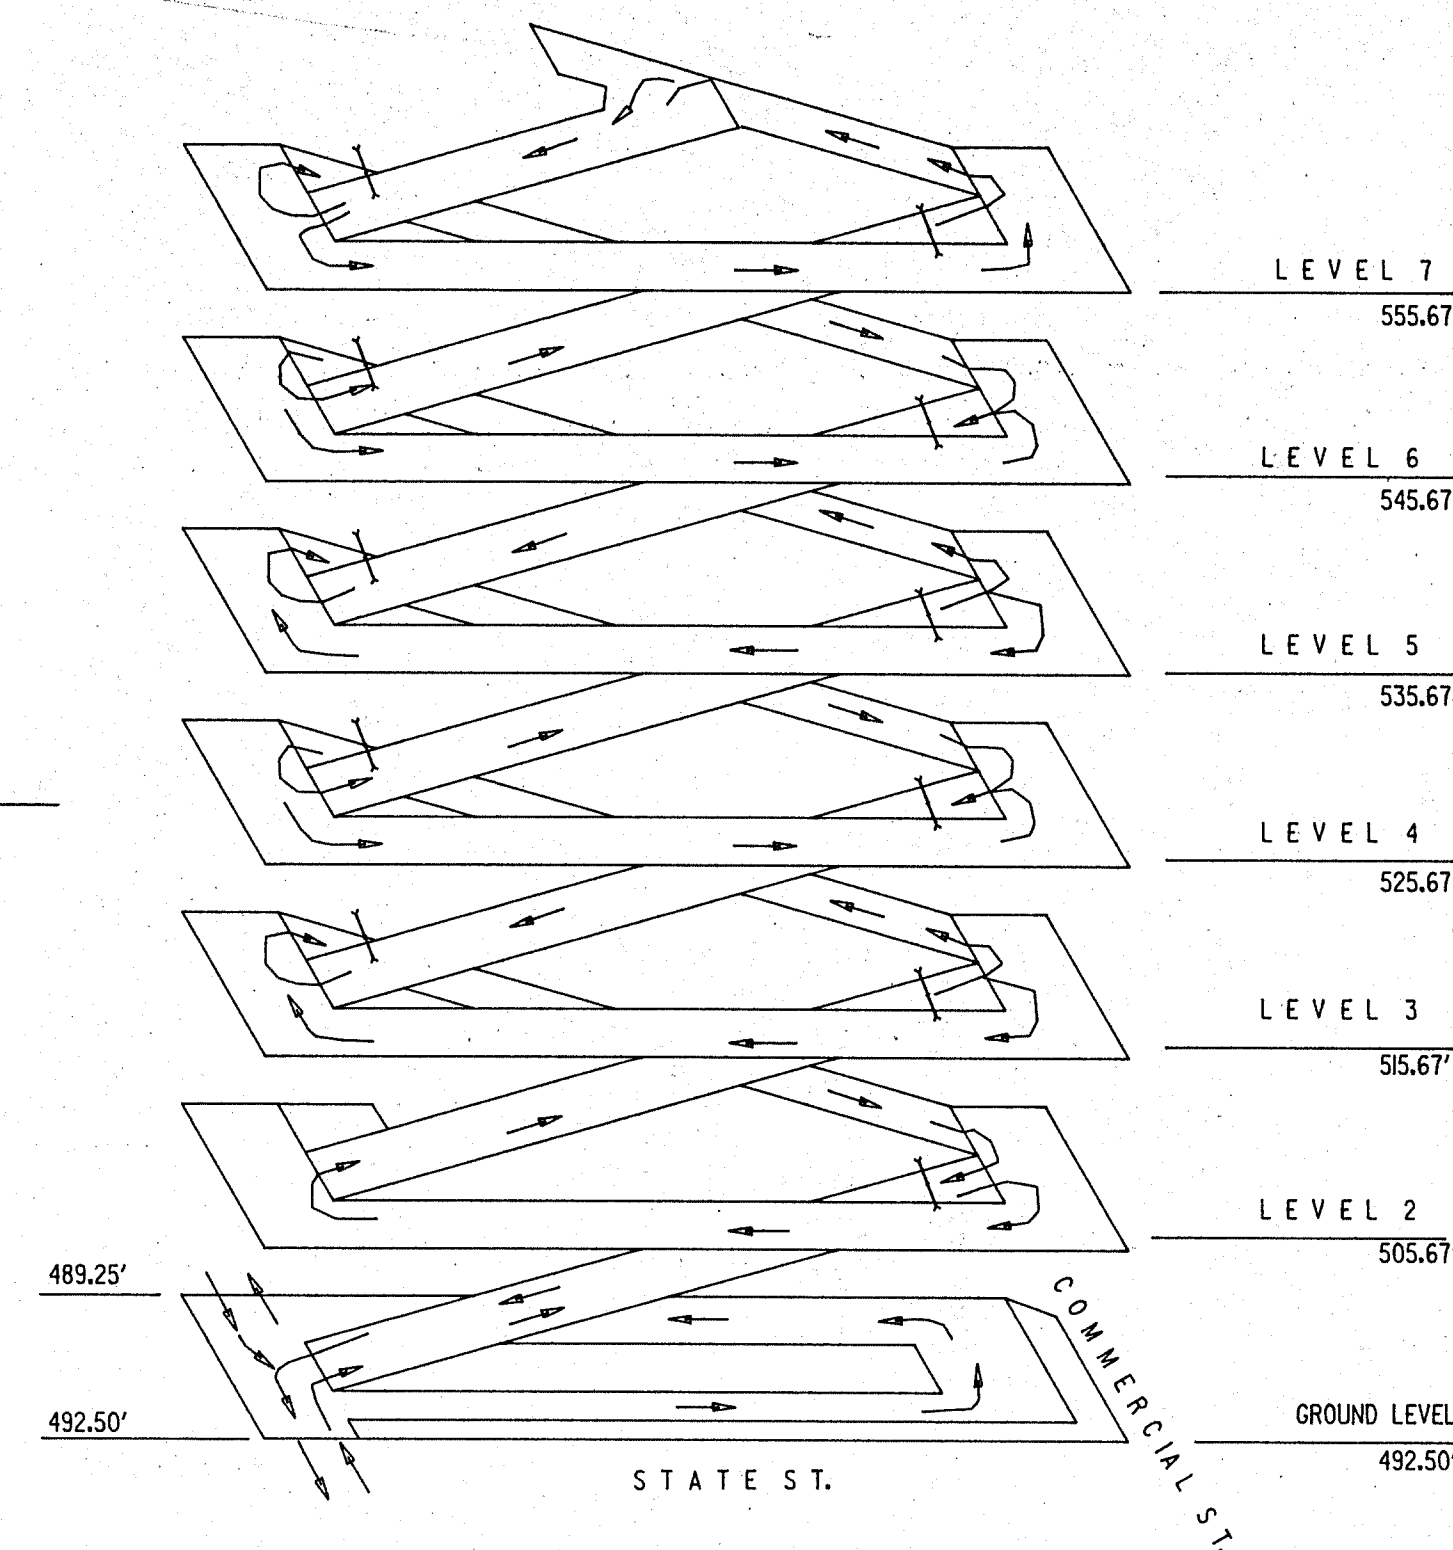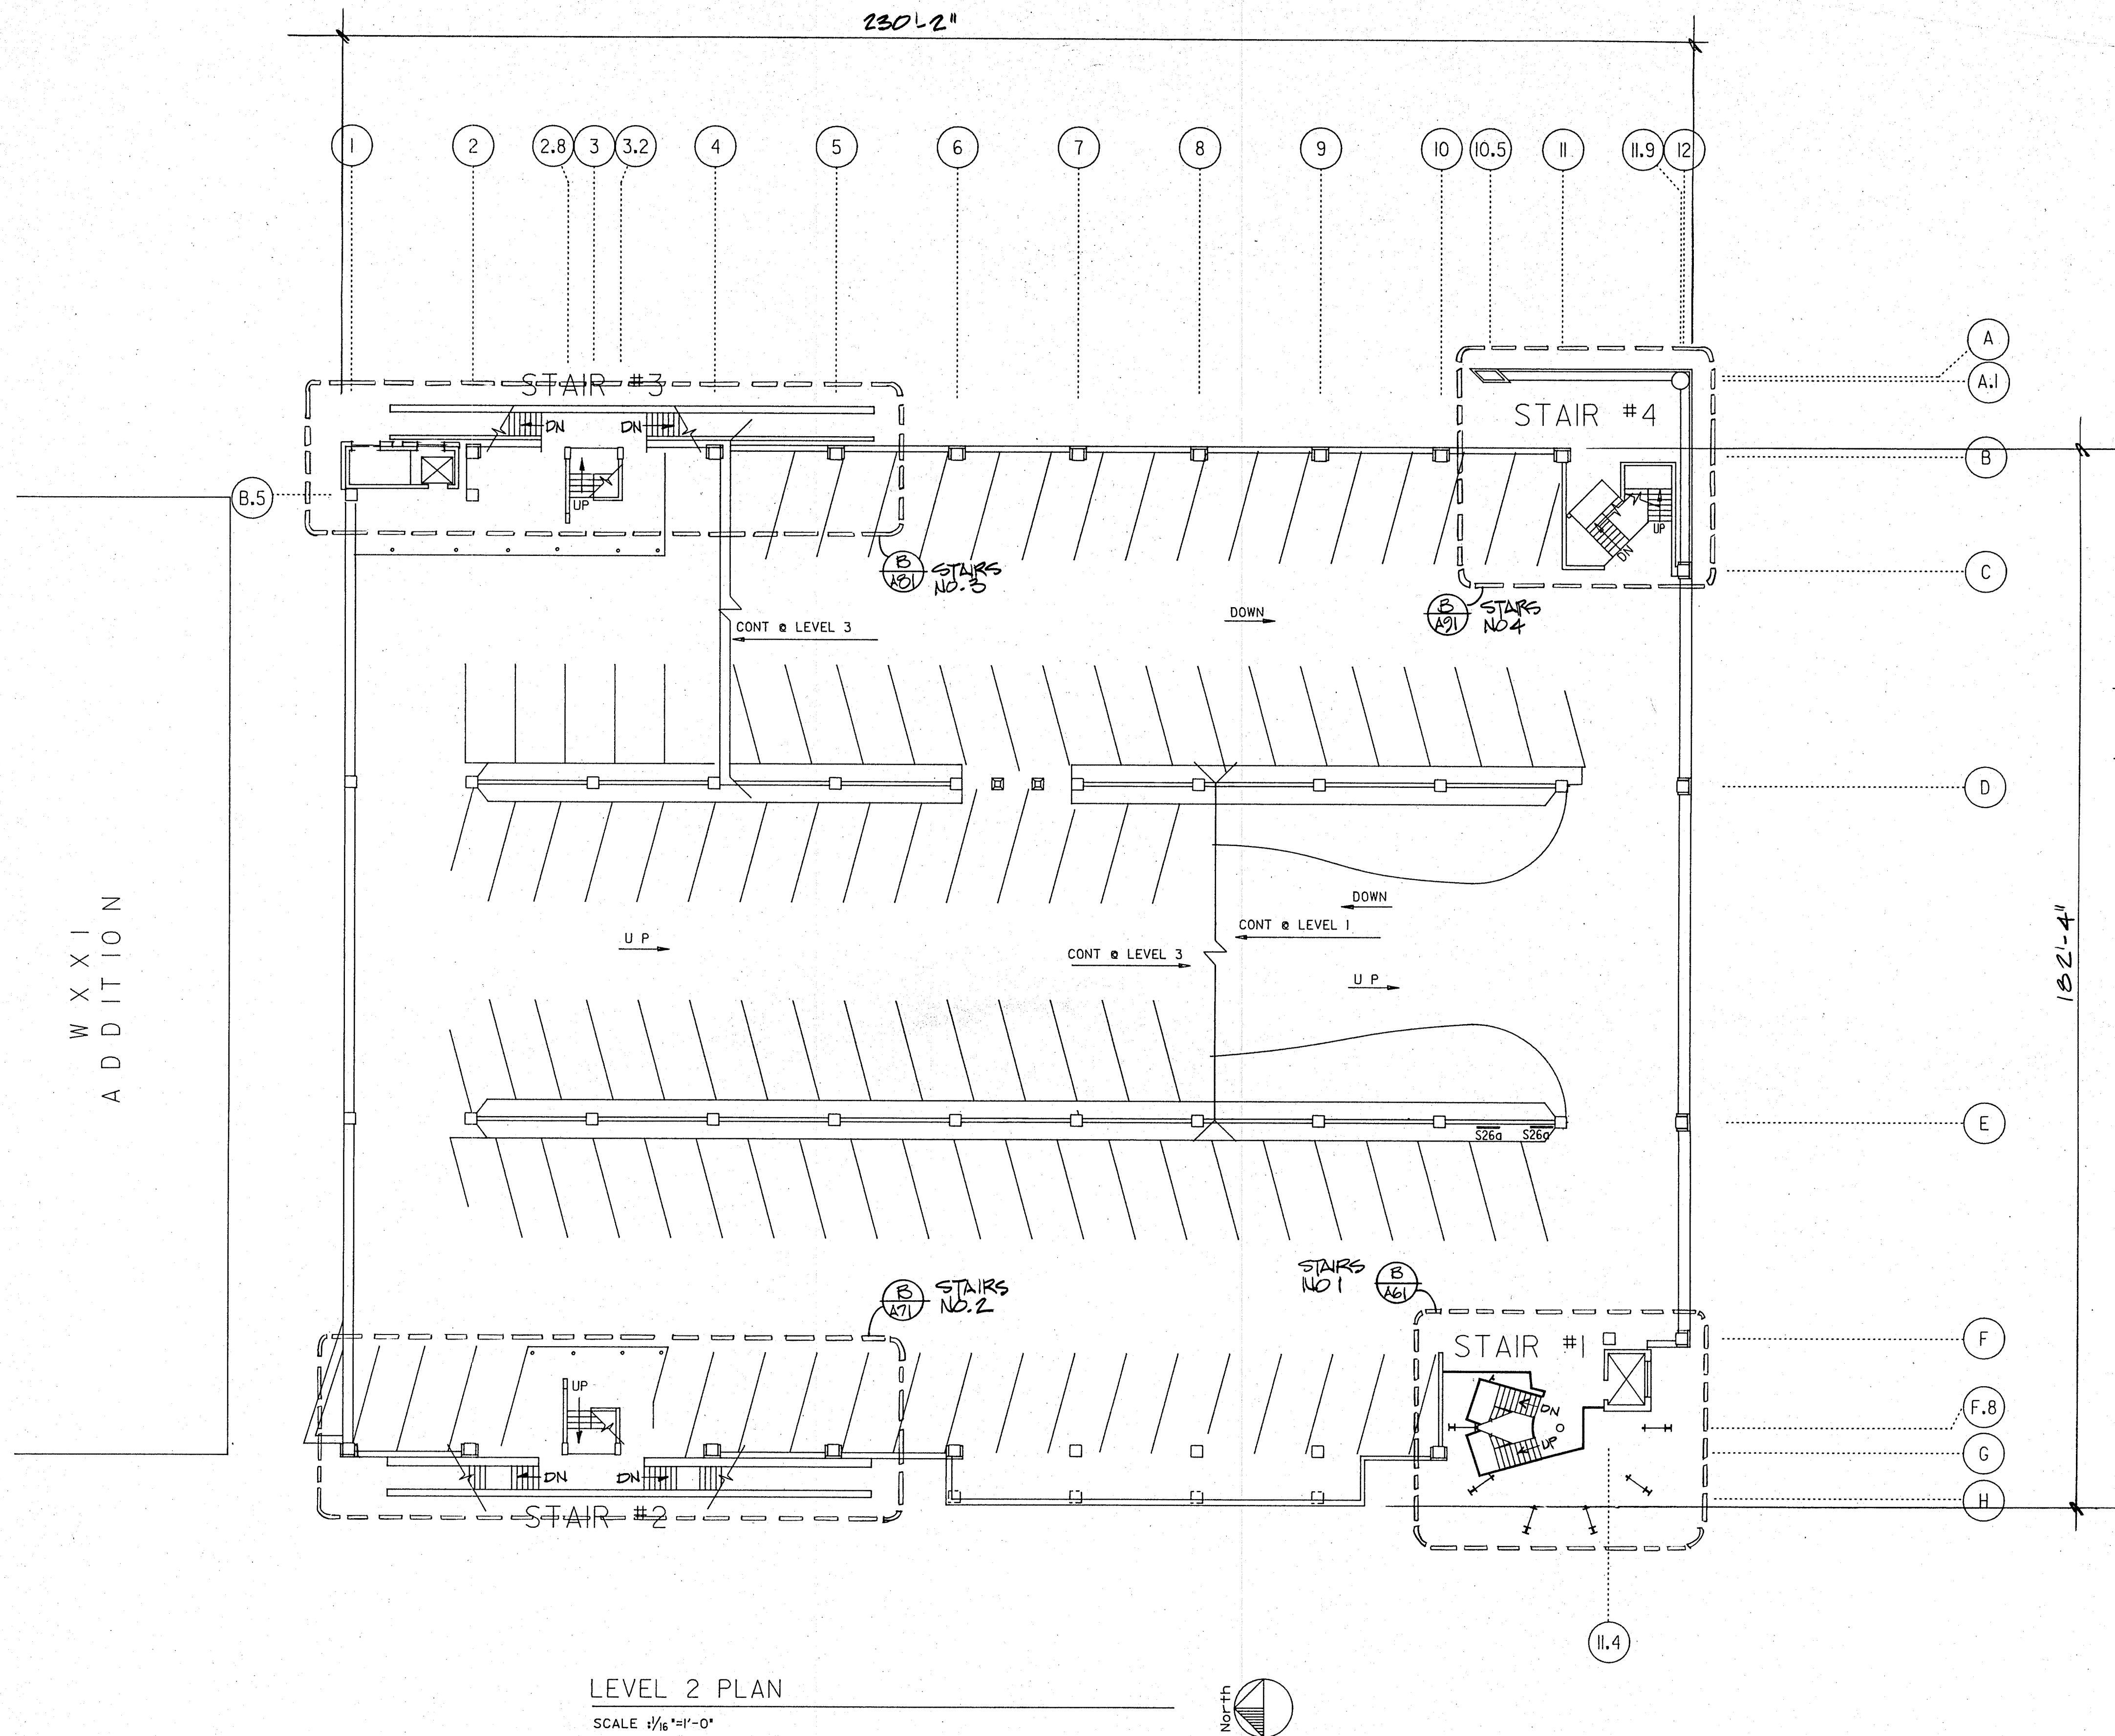


| NO. | REVISION | BY | DATE |
|-----|----------|----|------|
|     |          |    |      |
|     |          |    |      |
It is a violation of New York Education Law Article 15 Sec. 7203, for any person, unless he is acting under the direction of a licensed professional engineer or land surveyor, to offer or sell in any way, if an item bearing the seal of an engineer or land surveyor is altered, the drawing engineer or land surveyor is altered to the item his seal and notation "altered by" followed by his signature and the date of such alteration, and a specific description of the alteration.

Copyright © 1992

**LaBella**  
Engineering, Architecture and Surveying  
LaBella Associates, P.C.  
300 STATE STREET  
ROCHESTER, N.Y. 14604  
(716) 454-680

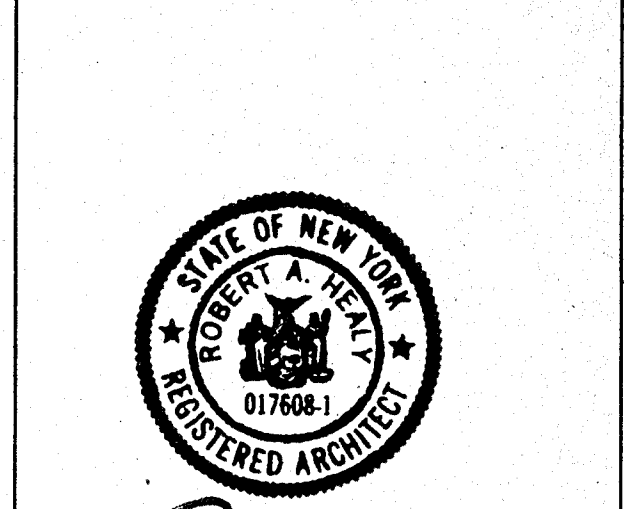


BY: *[Signature]*  
LISC. NO. 017608-1 DATE: 8-12-92

CLIENT  
**CITY OF ROCHESTER  
NEW YORK**  
**DEPARTMENT OF  
ENVIRONMENTAL  
SERVICES**  
**BUREAU OF  
MUNICIPAL FACILITIES**

PROJECT NAME  
**BROWN'S RACE  
PARKING GARAGE**  
**CITY OF ROCHESTER  
NEW YORK**

DRAWING TITLE  
**LEVEL 2 PLAN**

|                      |                         |
|----------------------|-------------------------|
| DESIGNED BY:         | LEB                     |
| DRAWN BY:            | MLA                     |
| CHECKED BY:          | LEB                     |
| APPROVED BY:         | RAH                     |
| FIELD BOOKS          | PROJECT NO.<br>91416    |
| SCALE: 1/16" = 1'-0" | DWG. NO.<br><b>A2.2</b> |
| DATE: 12 AUG 92      | FILE NO.                |
| FILE NO.             | SHEET OF                |

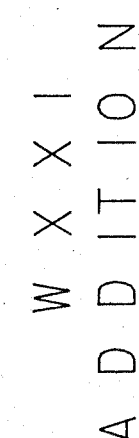

It is a violation of New York Education Law Article 145 Sec. 7203, for any person, unless he is acting under the direction of a licensed professional engineer or land surveyor, to alter an item in any way. If an item bearing the seal of an engineer or land surveyor is altered, the altering engineer or land surveyor shall affix to the item his seal and notation "altered by" followed by his signature and the date of such alteration, and a specific description of the alteration.

Copyright © 1992

Engineering, Architecture and Surveying

**LaBella Associates, P.C.**

300 STATE STREET  
ROCHESTER, N.Y. 14614  
(716) 454-6800



LISC. NO. 017699 DATE: 8-12-92

CLIENT

CITY OF ROCHESTER  
NEW YORK

DEPARTMENT OF  
ENVIRONMENTAL  
SERVICES

**BUREAU OF  
MUNICIPAL FACILITIES**

PROJECT NAME

**BROWN'S RACE  
PARKING GARAGE**

CITY OF ROCHESTER  
NEW YORK

DRAWING TITLE

### LEVEL 3 PLAN

DESIGNED BY: LEB

DRAWN BY: MLA

CHECKED BY: LEB

APPROVED BY: RAH

|             |             |
|-------------|-------------|
| FIELD BOOKS | PROJECT NO. |
|-------------|-------------|

91416

SCALE: 1/16" = 1' 0"

DATE 12/12/22


DATE: 12 AUG 72

|         |  |
|---------|--|
| DWG. NO |  |
|---------|--|

A2

A2.

SHEET 0

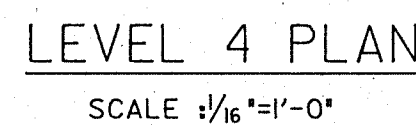

It is a violation of New York Education Law Article 145 Sec. 7209, for any person, unless he is acting under the direction of a licensed professional engineer or land surveyor, to alter an item in any way, if an item bearing the seal of an engineer or land surveyor is altered, the altering engineer or land surveyor shall affix to the item his seal and notation "altered by" followed by his signature and the date of such alteration, and a specific description of the alteration.

Copyright © 1992

**LABELLA**  
Engineering, Architecture and Surveying

**LaBella Associates, P.C.**

300 STATE STREET  
ROCHESTER, N.Y. 14614  
(716) 454-6110



BY: [Signature]  
LISC. NO. 017608-1 DATE: 8.12.92

CLIENT

CITY OF ROCHESTER  
NEW YORK

DEPARTMENT OF  
ENVIRONMENTAL  
SERVICES

**BUREAU OF  
MUNICIPAL FACILITIES**

PROJECT NAME

**BROWN'S RACE  
PARKING GARAGE**

CITY OF ROCHESTER  
NEW YORK

DRAWING TITLE

### LEVEL 4 PLAN

DESIGNED BY: IFR

DRAWN BY: M-LA

CHECKED BY: LFB

APPROVED BY: RAH

|             |             |
|-------------|-------------|
| FIELD BOOKS | PROJECT NO. |
|-------------|-------------|

91416

SCALE: 1/4" = 1'-0"

DWG. NO

|        |  |
|--------|--|
| 116-10 |  |
|--------|--|


A2

DATE: 12



## AZ.

FILE NO.

SHEET 0

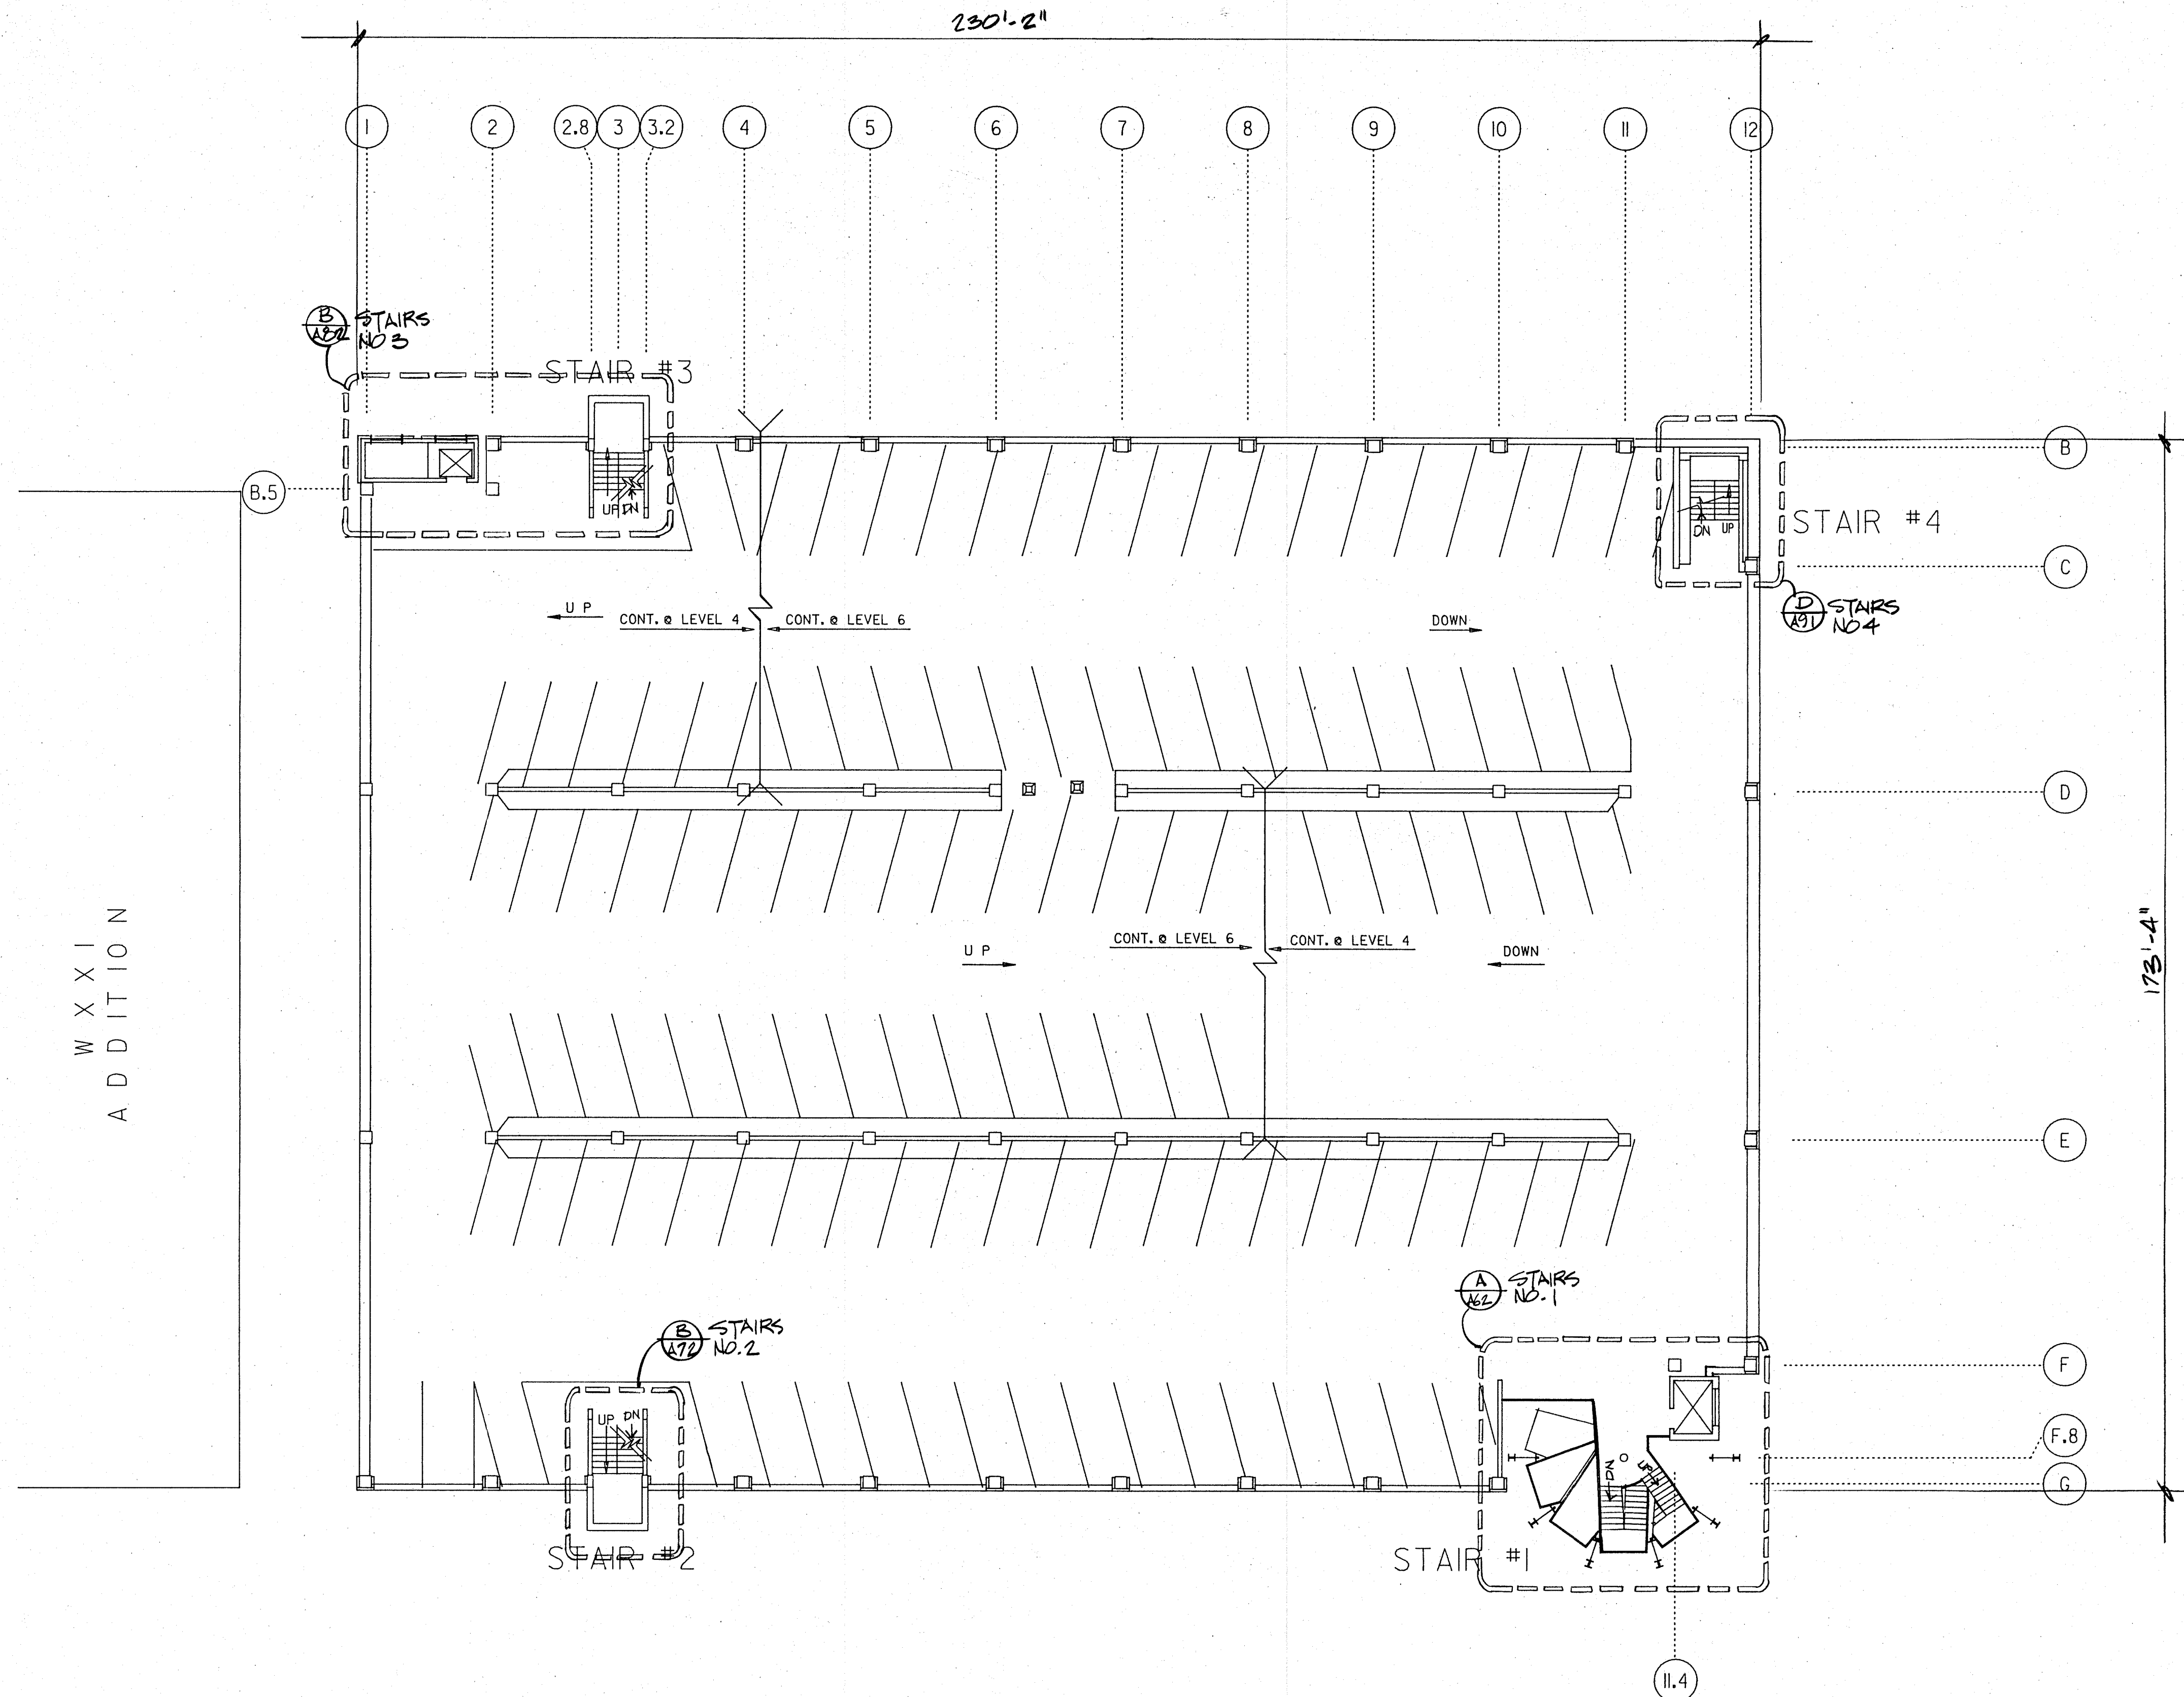

LEVEL 5 PLAN  
SCALE 1/16"=1'-0"

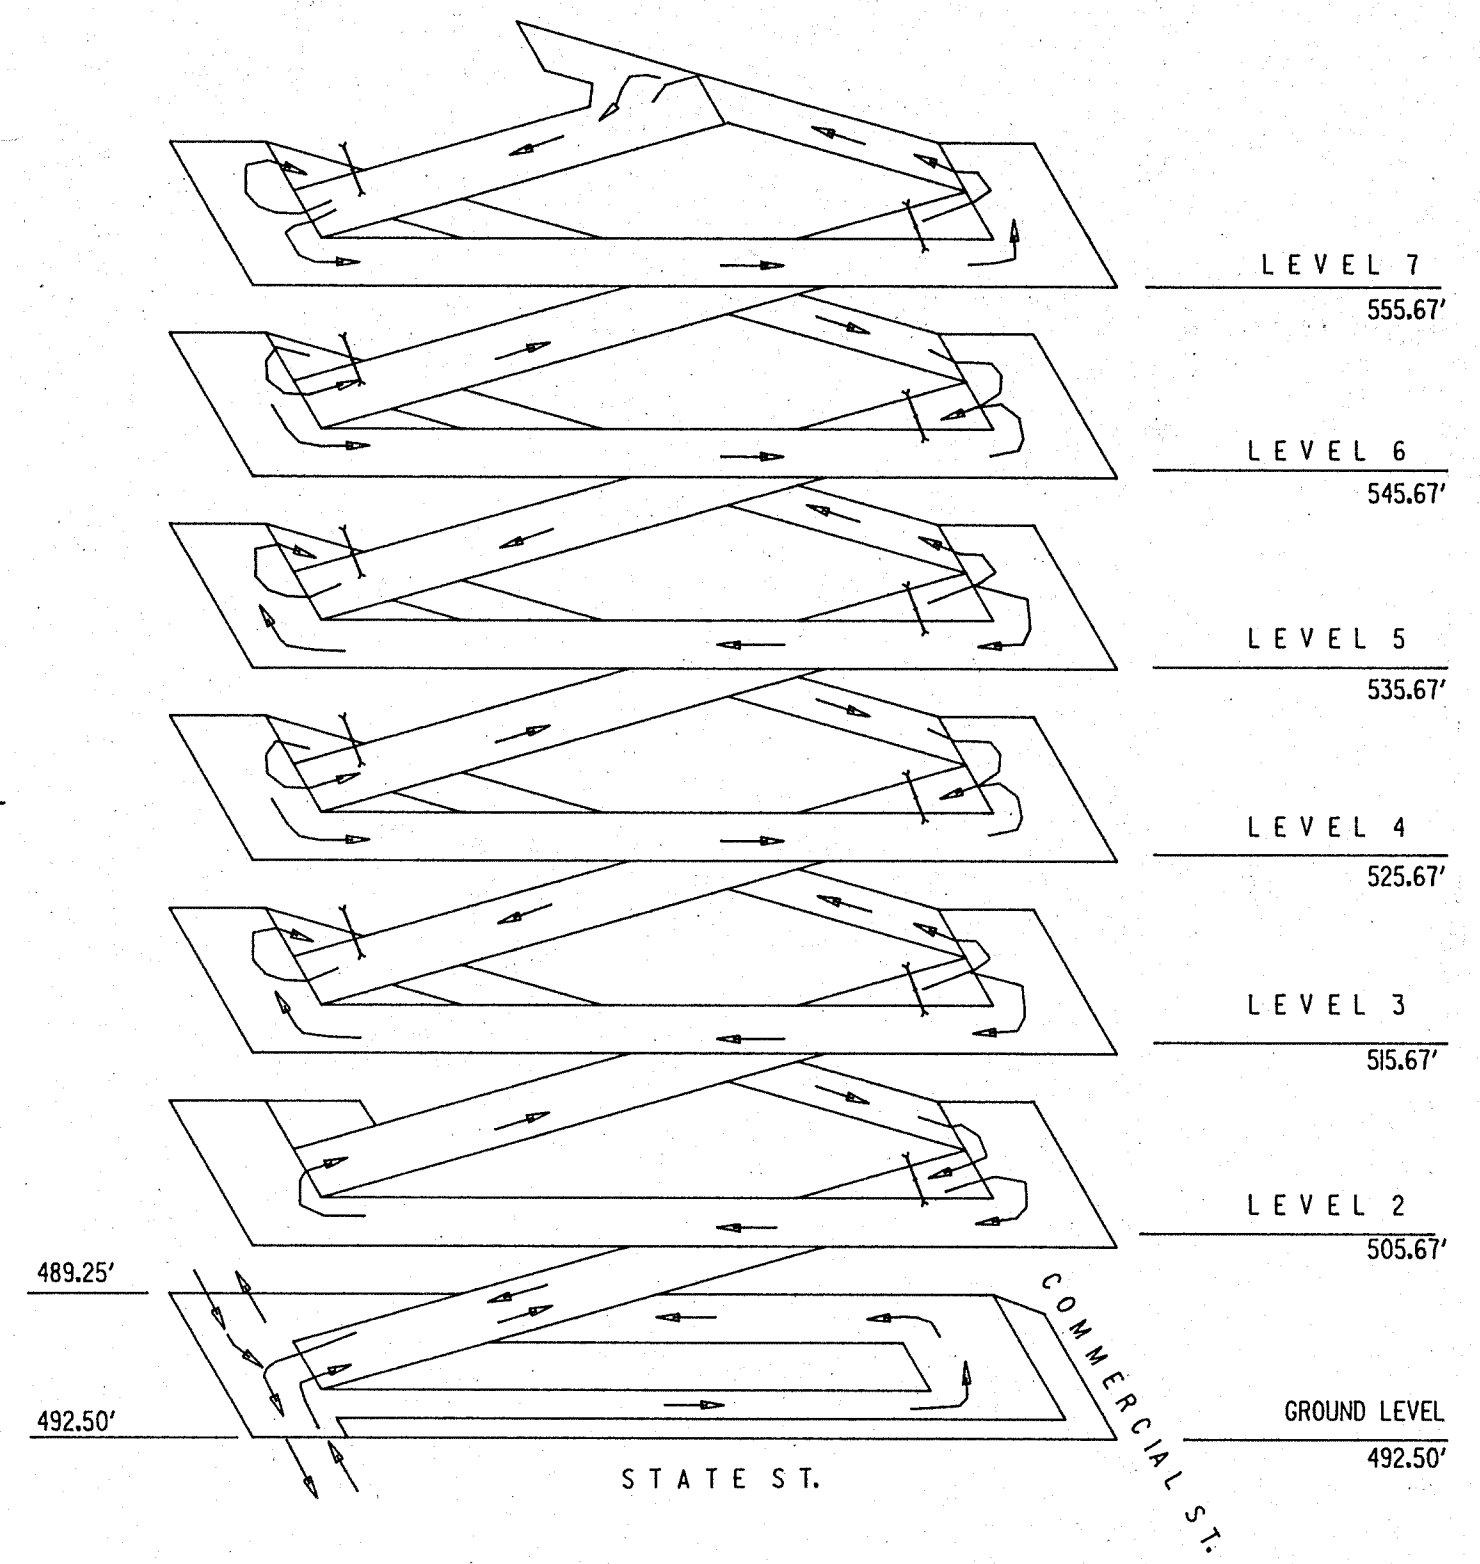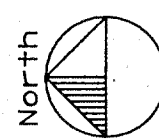


ISOMETRIC  
NO SCALE

| NO. | REVISION | BY | DATE |
|-----|----------|----|------|
|     |          |    |      |
|     |          |    |      |
It is a violation of New York Education Law Article 15 Sec. 1205, for any person, unless he is acting under the direction of a licensed professional engineer or land surveyor, to alter or item in any way, if an item bearing the seal of an engineer or land surveyor is altered, the altering engineer or land surveyor shall affix to the item his seal and notation "altered by" followed by his signature and the date of such alteration, and a specific description of the alteration.

Copyright © 1992.

**LABELLA**  
Engineering, Architecture and Surveying  
LaBella Associates, P.C.  
300 STATE STREET  
ROCHESTER, N.Y. 14604  
(716) 454-6800

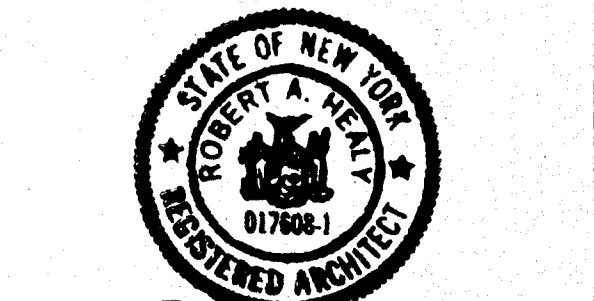


BY: *[Signature]*  
LIC. NO. 017600-1 DATE: 8-12-92

CLIENT  
CITY OF ROCHESTER  
NEW YORK  
DEPARTMENT OF ENVIRONMENTAL SERVICES  
BUREAU OF MUNICIPAL FACILITIES



PROJECT NAME  
BROWN'S RACE PARKING GARAGE  
CITY OF ROCHESTER  
NEW YORK

DRAWING TITLE  
LEVEL 5 PLAN

|                    |             |
|--------------------|-------------|
| DESIGNED BY:       | LEB         |
| DRAWN BY:          | MLA         |
| CHECKED BY:        | LEB         |
| APPROVED BY:       | RAH         |
| FIELD BOOKS        | PROJECT NO. |
|                    | 91416       |
| SCALE: 1/16"=1'-0" | DWG. NO.    |
| DATE: 12 AUG 92    | A2.5        |
| FILE NO.           | SHEET OF    |

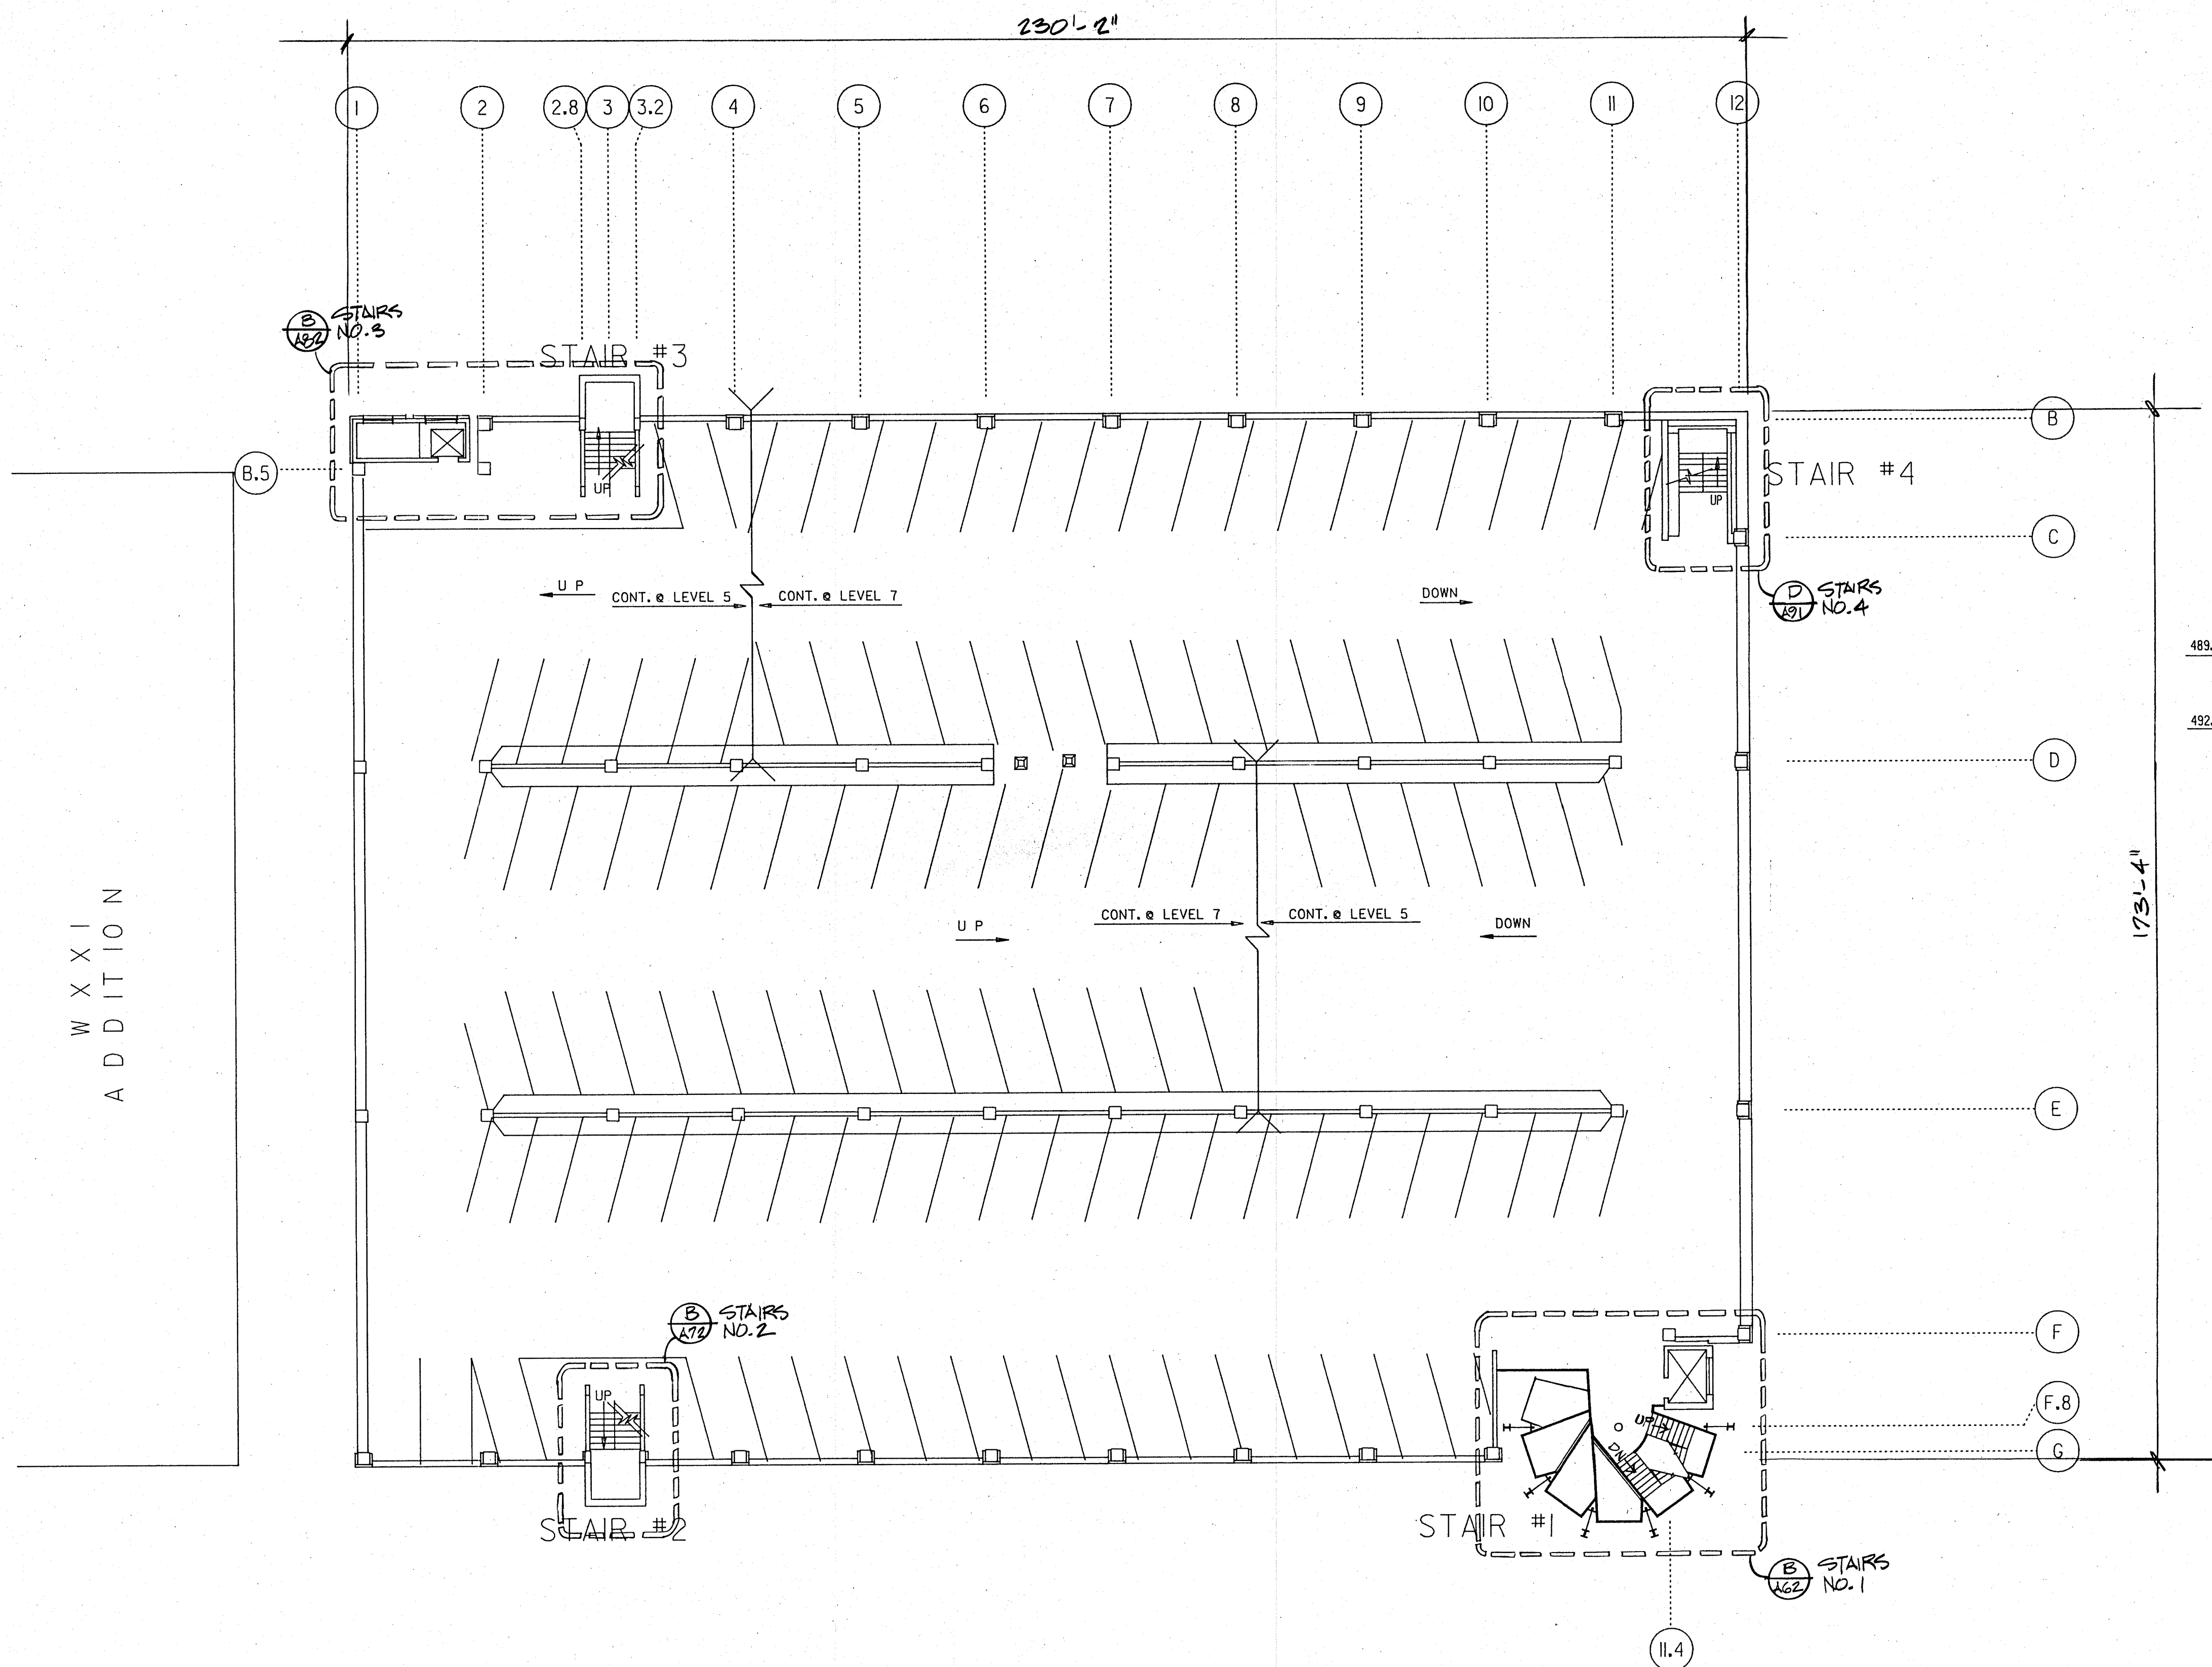

LEVEL 6 PLAN  
SCALE: 1/16" = 1'-0"

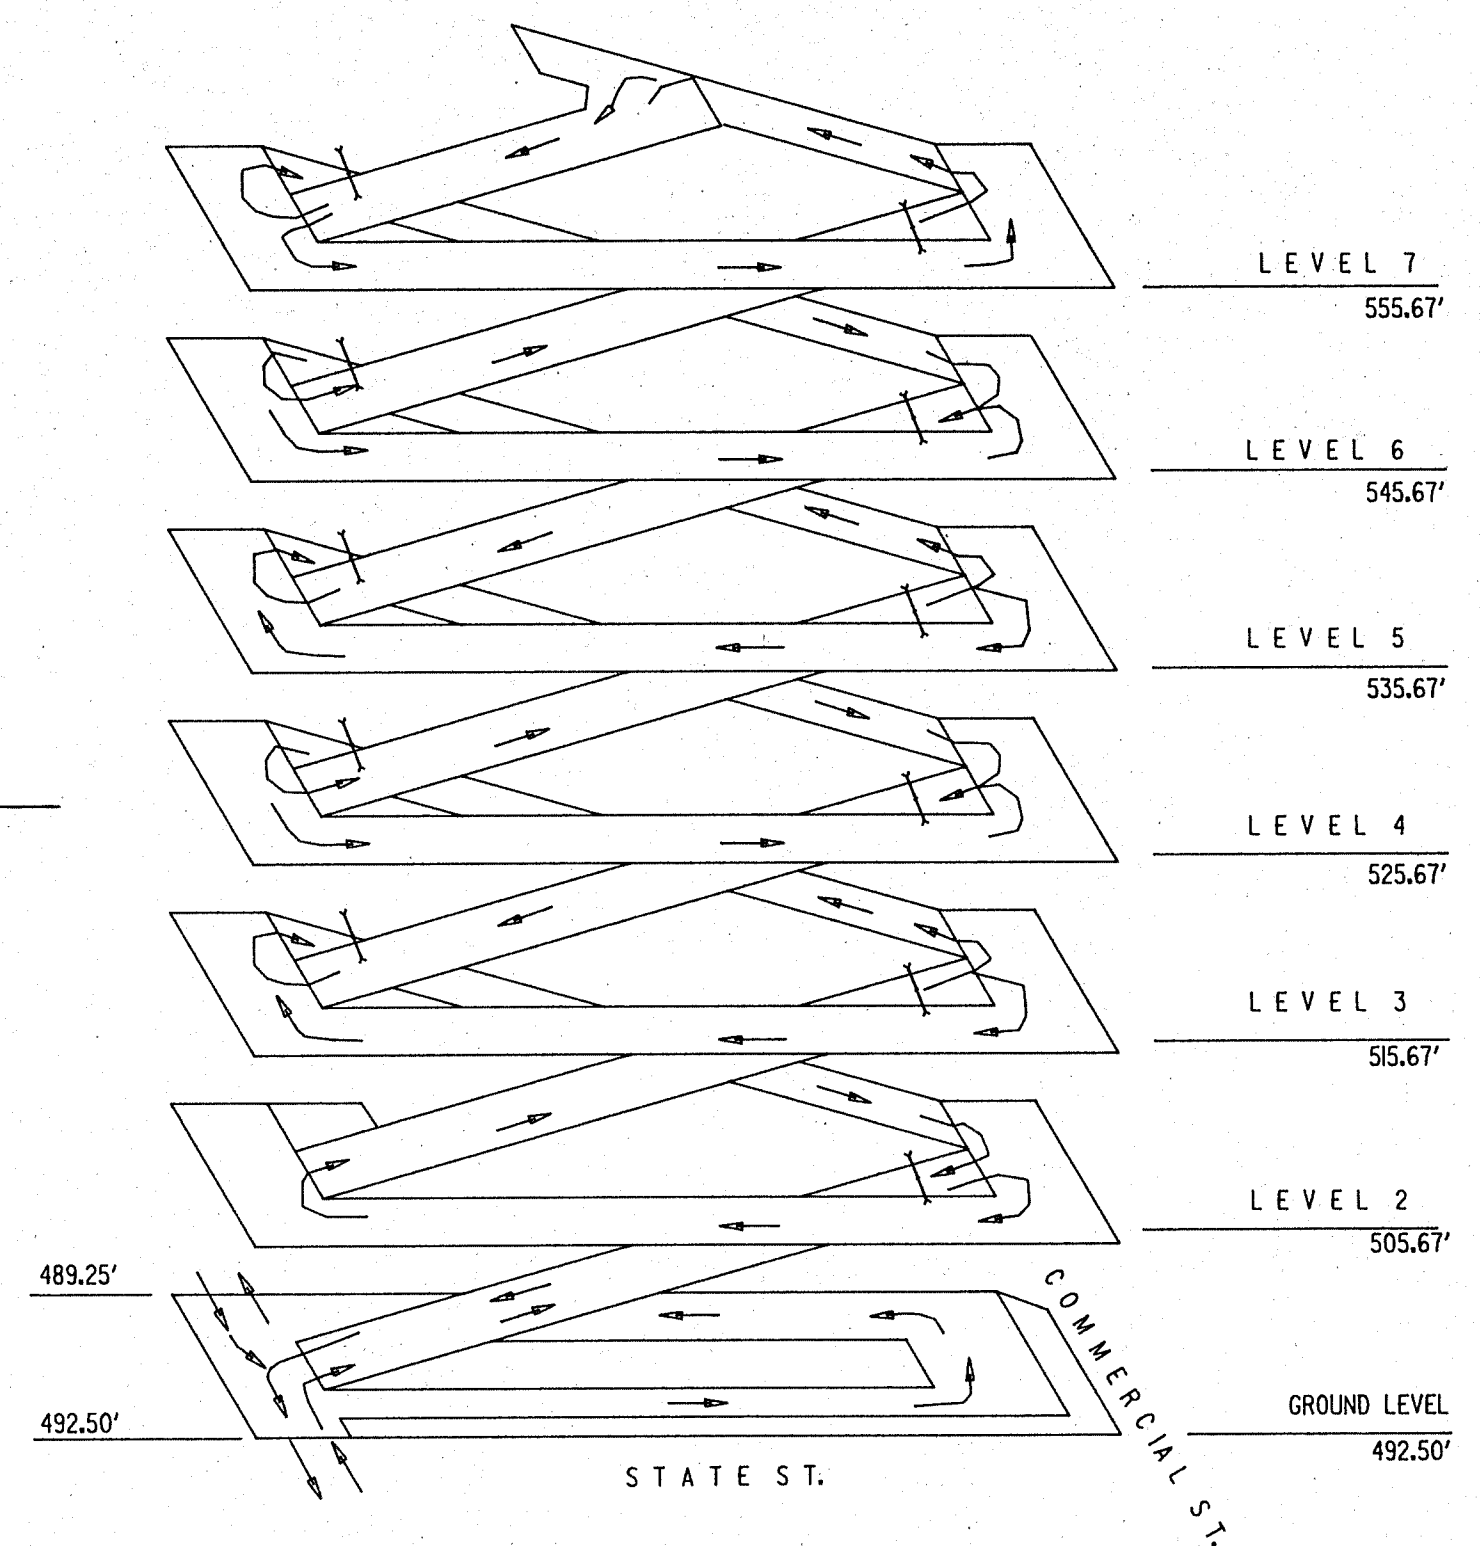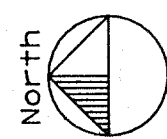

ISOMETRIC  
NO SCALE

| NO. | REVISION | BY | DATE |
|-----|----------|----|------|
|     |          |    |      |
|     |          |    |      |
It is a violation of New York Education Law Article 16, Sec. 1705, for any person, unless he is acting under the direction of a licensed professional engineer or land surveyor, to offer or place in any way, if an item bearing the seal of an engineer or land surveyor is altered, the altering engineer or land surveyor shall affix to the item his seal and notation "altered by" followed by his signature and the date of such alteration, and a specific description of the alteration.

Copyright © 1992.

**LABELLA**  
Engineering, Architecture and Surveying

LaBella Associates, P.C.  
300 STATE STREET  
ROCHESTER, N.Y. 14614  
(716) 454-6800

STATE OF NEW YORK  
ROBERT A. HEAL  
017608.1  
REGISTERED ARCHITECT

BY:   
LIC. NO. 017608.1 DATE: 8-12-92

CLIENT  
CITY OF ROCHESTER  
NEW YORK  
DEPARTMENT OF  
ENVIRONMENTAL  
SERVICES  
BUREAU OF  
MUNICIPAL FACILITIES



PROJECT NAME  
BROWN'S RACE  
PARKING GARAGE  
CITY OF ROCHESTER  
NEW YORK

DRAWING TITLE  
LEVEL 6 PLAN

DESIGNED BY: LEB  
DRAWN BY: MLA  
CHECKED BY: LEB  
APPROVED BY: RAH

FIELD BOOKS PROJECT NO.  
91416

SCALE: 1/16" = 1'-0" DWG. NO.  
DATE: 12 AUG 92 A2.6  
FILE NO. SHEET OF

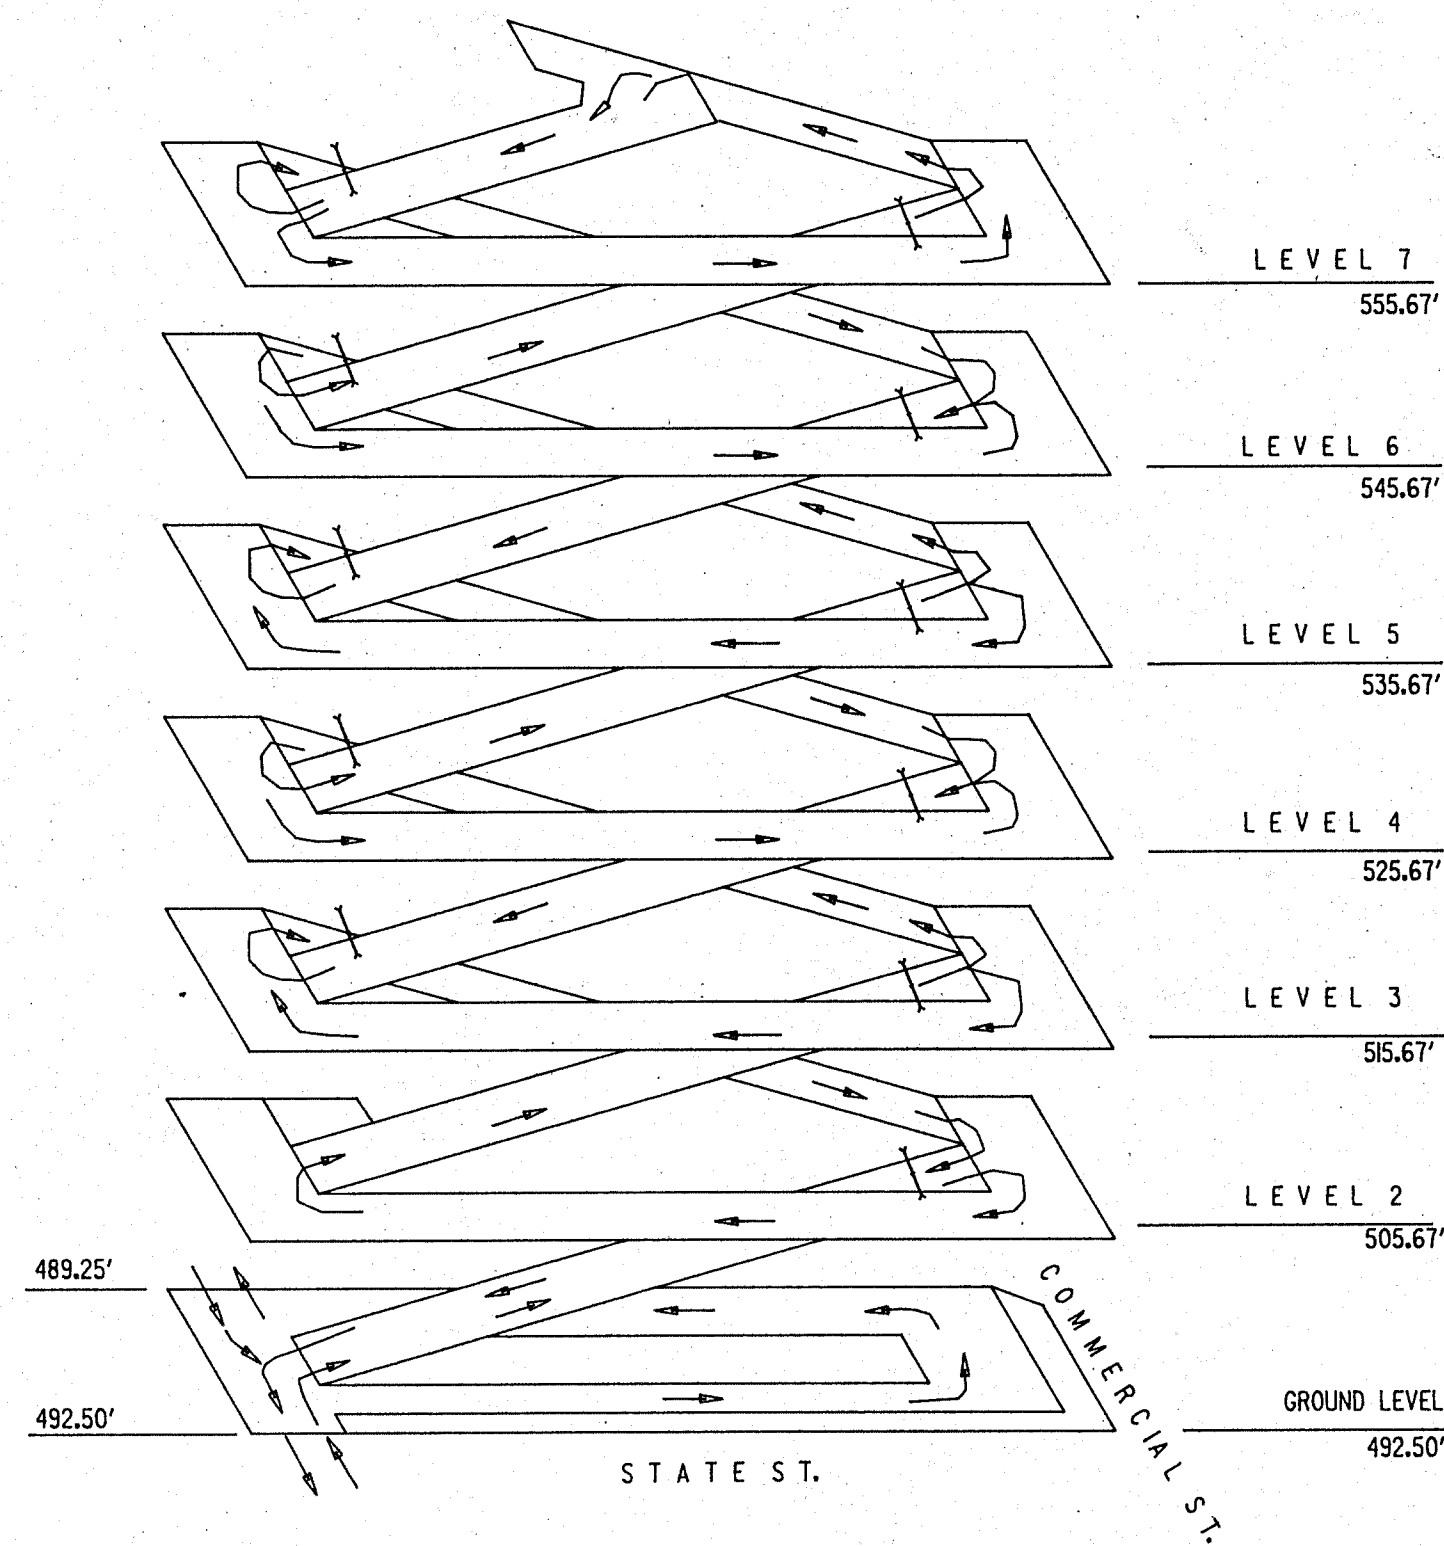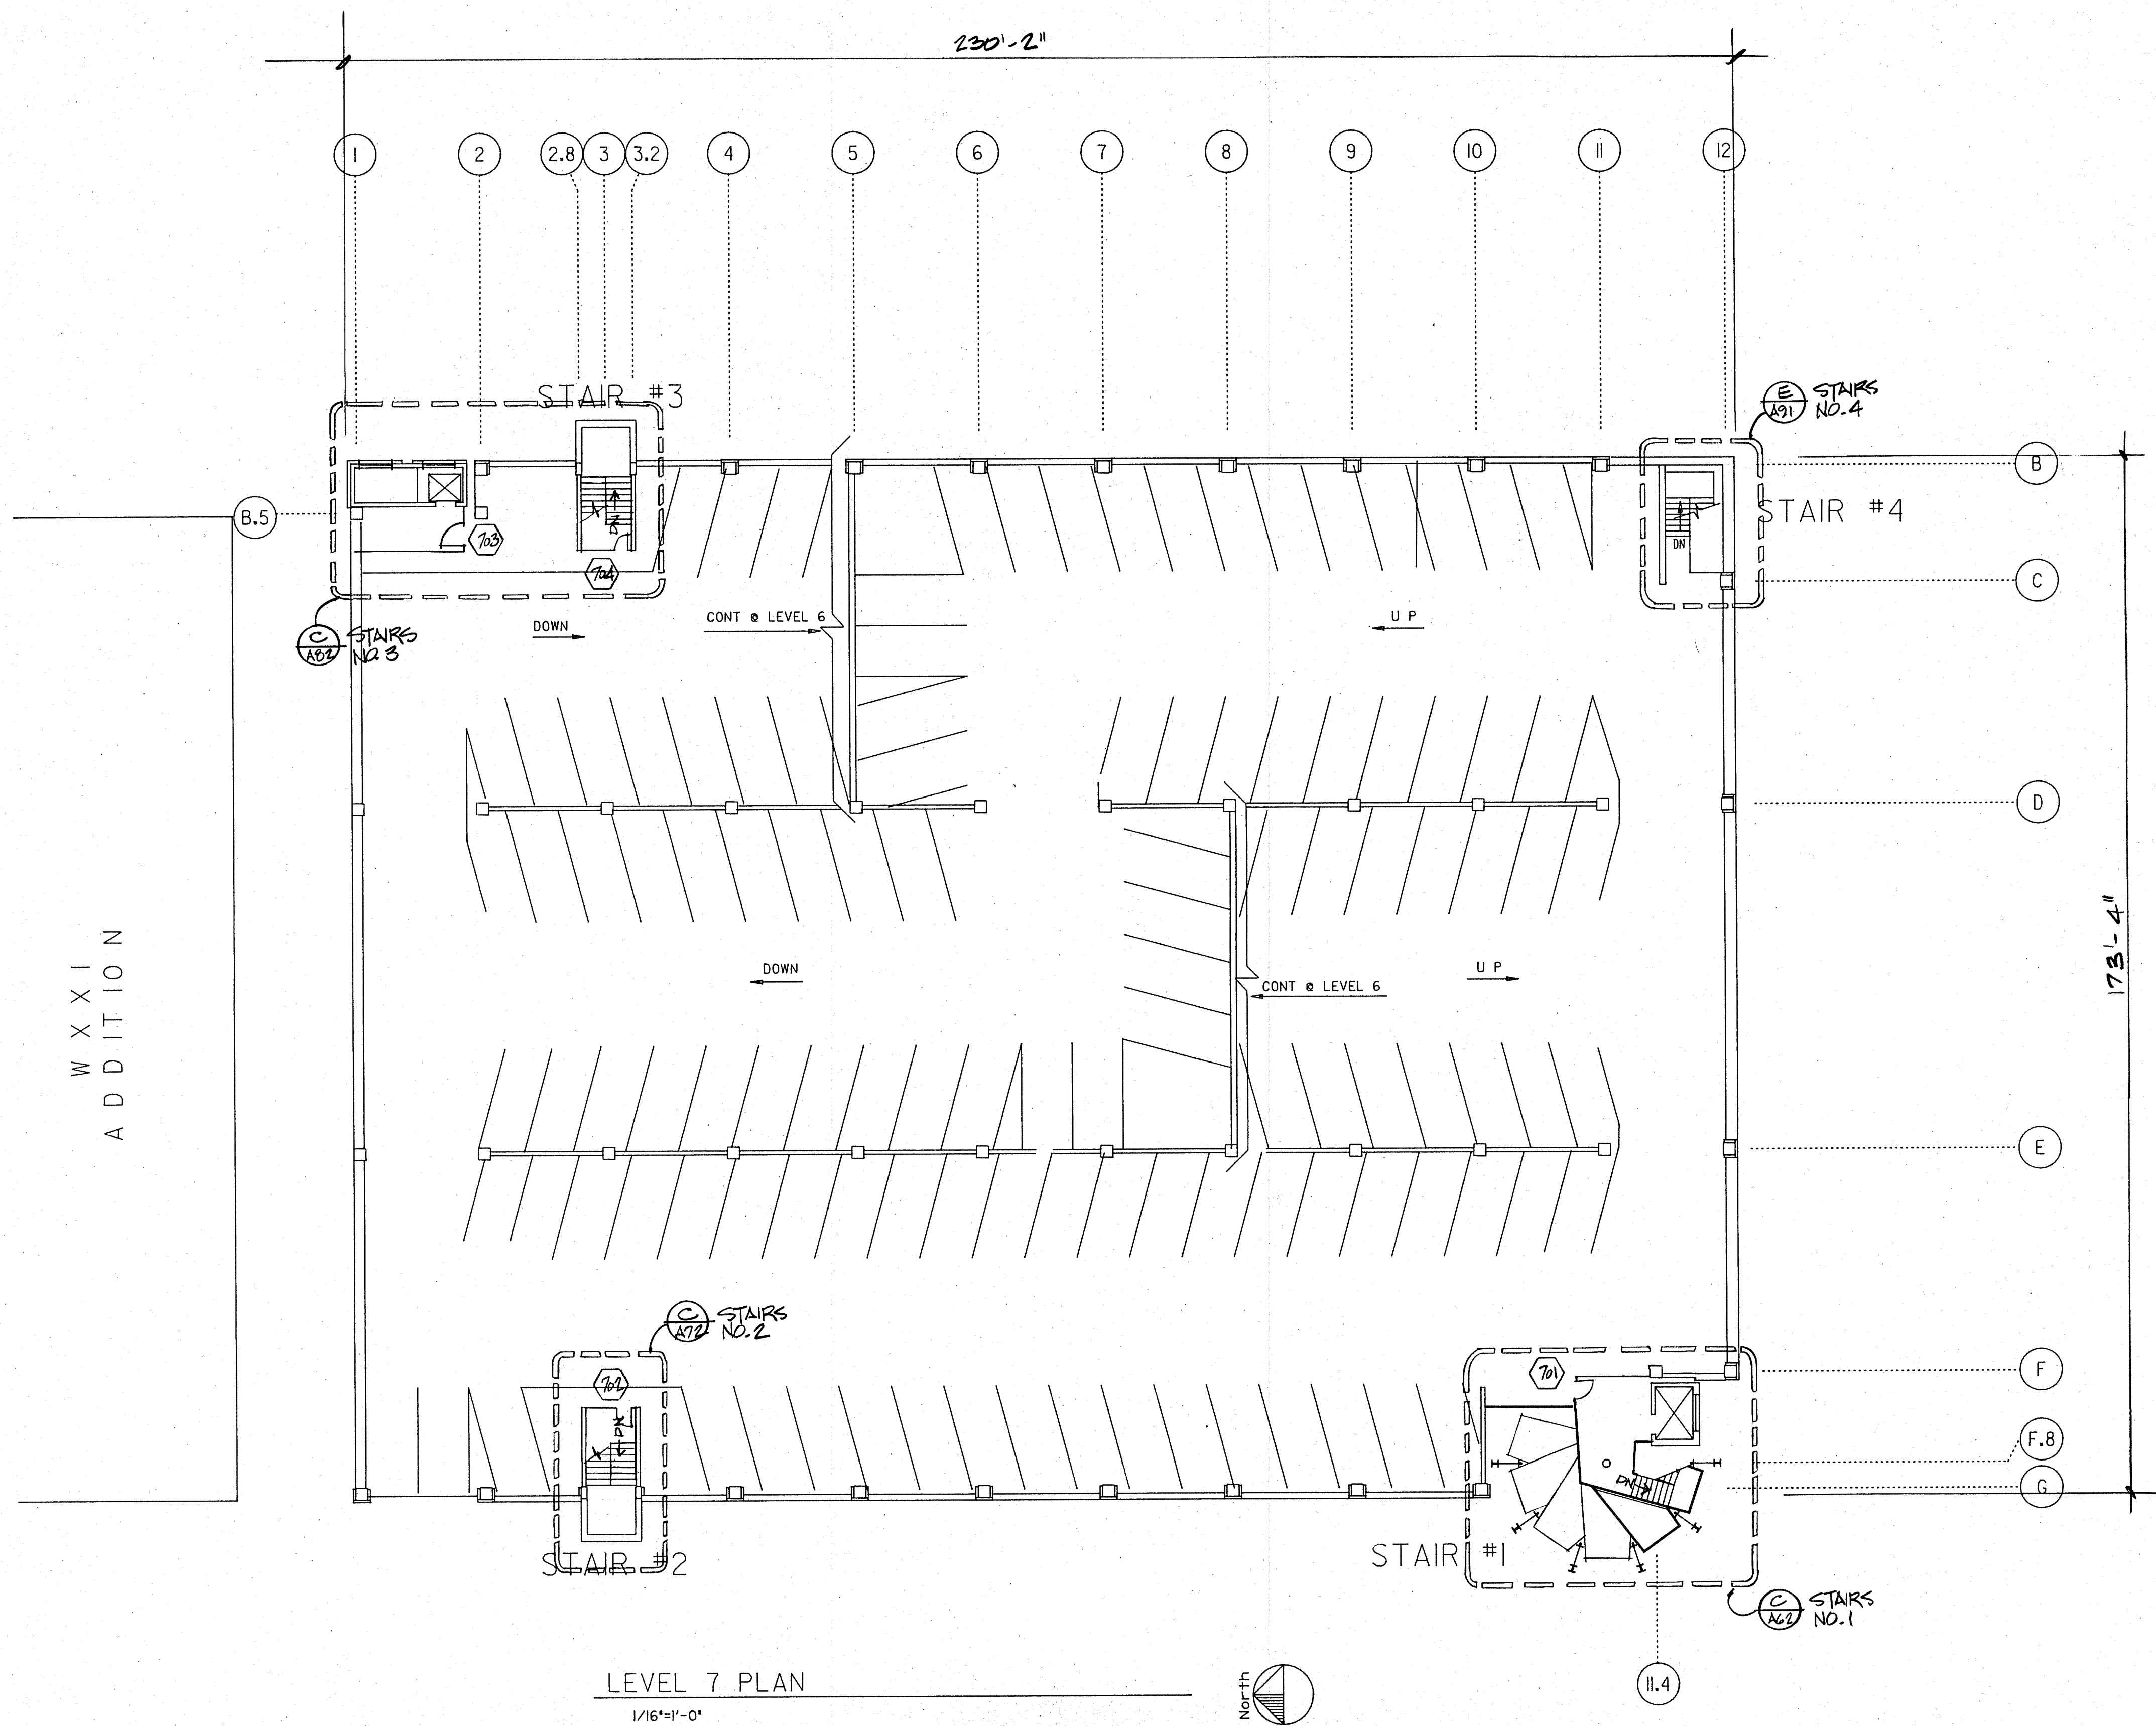

ISOMETRIC  
NO SCALE

| NO. | REVISION | BY | DATE |
|-----|----------|----|------|
|     |          |    |      |
|     |          |    |      |
It is a violation of New York Education Law Article 16 Sec. 7205, for any person, unless he is acting under the direction of a licensed professional engineer or land surveyor, to alter or free in any way, if on them bearing the seal of an engineer or land surveyor is altered, the altering engineer or land surveyor and prints to the then his seal and notation "altered by" followed by his signature and the date of such alteration, and a specific description of the alteration.

Copyright © 1992

**LABELLA**  
Engineering, Architecture and Surveying  
LaBella Associates, P.C.  
300 STATE STREET  
ROCHESTER, N.Y. 14604  
(716) 454-580


STATE OF NEW YORK  
ROBERT A. HENRY  
REGISTERED ARCHITECT  
017608-1  
BY:   
LISC. NO. 072087 DATE: 8-12-92

CLIENT  
CITY OF ROCHESTER  
NEW YORK  
DEPARTMENT OF  
ENVIRONMENTAL  
SERVICES  
BUREAU OF  
MUNICIPAL FACILITIES

PROJECT NAME  
BROWN'S RACE  
PARKING GARAGE  
CITY OF ROCHESTER  
NEW YORK

DRAWING TITLE  
LEVEL 7 PLAN

|                    |                      |
|--------------------|----------------------|
| DESIGNED BY:       | LEB                  |
| DRAWN BY:          | MLA                  |
| CHECKED BY:        | LEB                  |
| APPROVED BY:       | RAH                  |
| FIELD BOOKS        | PROJECT NO.<br>91416 |
| SCALE: 1/16"=1'-0" | DWG. NO.<br>A2.7     |
| DATE: 12 AUG 92    | SHEET OF             |
| FILE NO.           |                      |

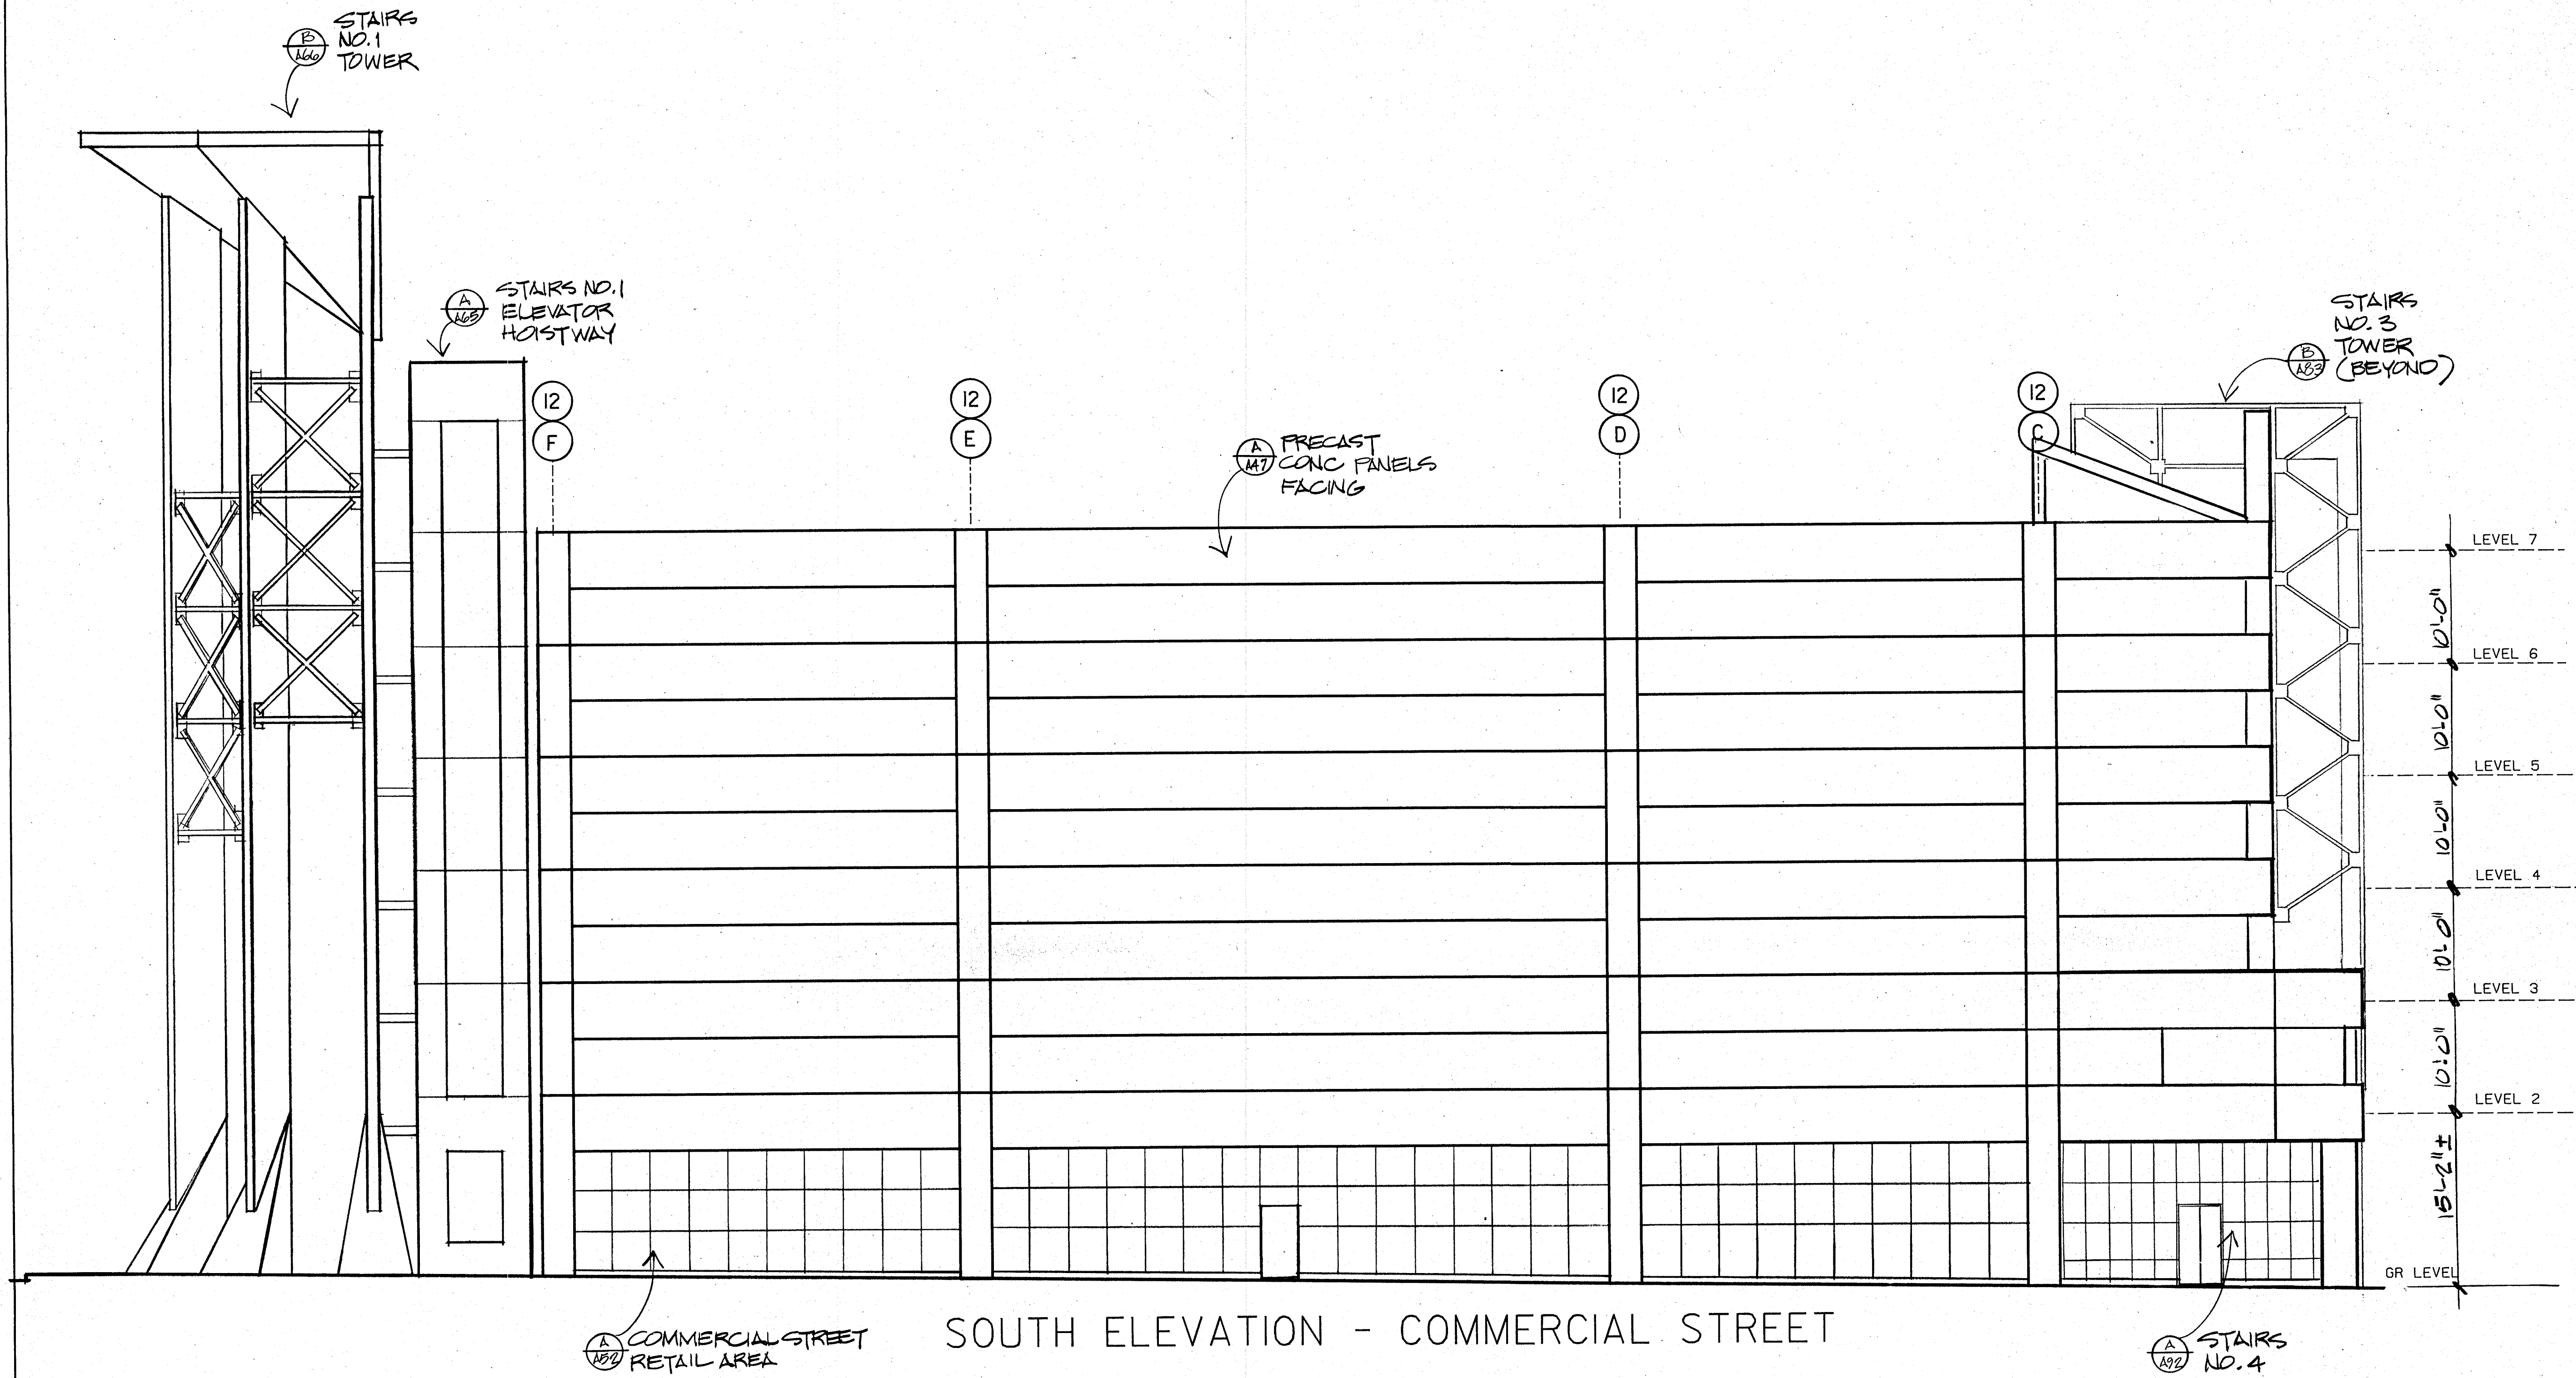


| NO. | REVISION | BY | DATE |
|-----|----------|----|------|
|     |          |    |      |
|     |          |    |      |
It is a violation of New York Education Law Article 145 Sec. 1203, for any person, unless he is acting under the direction of a licensed professional engineer or land surveyor, to offer or place in any way, or in any bearing the seal of an engineer or land surveyor is altered, the drawing engineer or land surveyor's seal or the firm's seal and notation altered by followed by his signature and the date of such alteration, and a specific description of the alteration.

Copyright © 1992.

**LaBELLA**  
Engineering, Architecture and Surveying  
LaBella Associates, P.C.  
300 STATE STREET  
ROCHESTER, N.Y. 14604  
(716) 454-6800

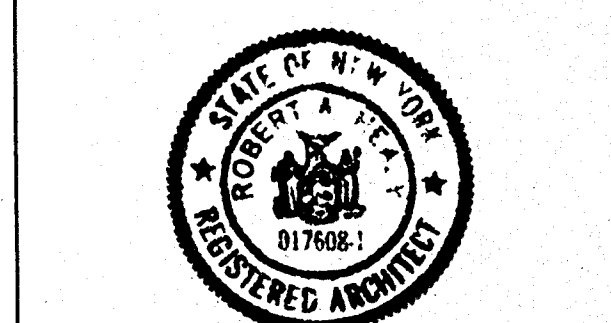


BY: *[Signature]*  
LISC. NO. 017608.1 DATE: 8-12-92

CLIENT  
CITY OF ROCHESTER  
NEW YORK  
DEPARTMENT OF  
ENVIRONMENTAL  
SERVICES  
BUREAU OF  
MUNICIPAL FACILITIES

PROJECT NAME  
BROWN'S RACE  
PARKING GARAGE  
CITY OF ROCHESTER  
NEW YORK

DRAWING TITLE  
SOUTH  
ELEVATION

|                     |                      |
|---------------------|----------------------|
| DESIGNED BY:        |                      |
| DRAWN BY:           |                      |
| CHECKED BY:         | LEB                  |
| APPROVED BY:        | RAH                  |
| FIELD BOOKS         | PROJECT NO.<br>91416 |
| SCALE: 1/8" = 1'-0" | DWG. NO.<br>A3-1     |
| DATE: 12 AUG 92     |                      |
| FILE NO.            | SHEET OF             |

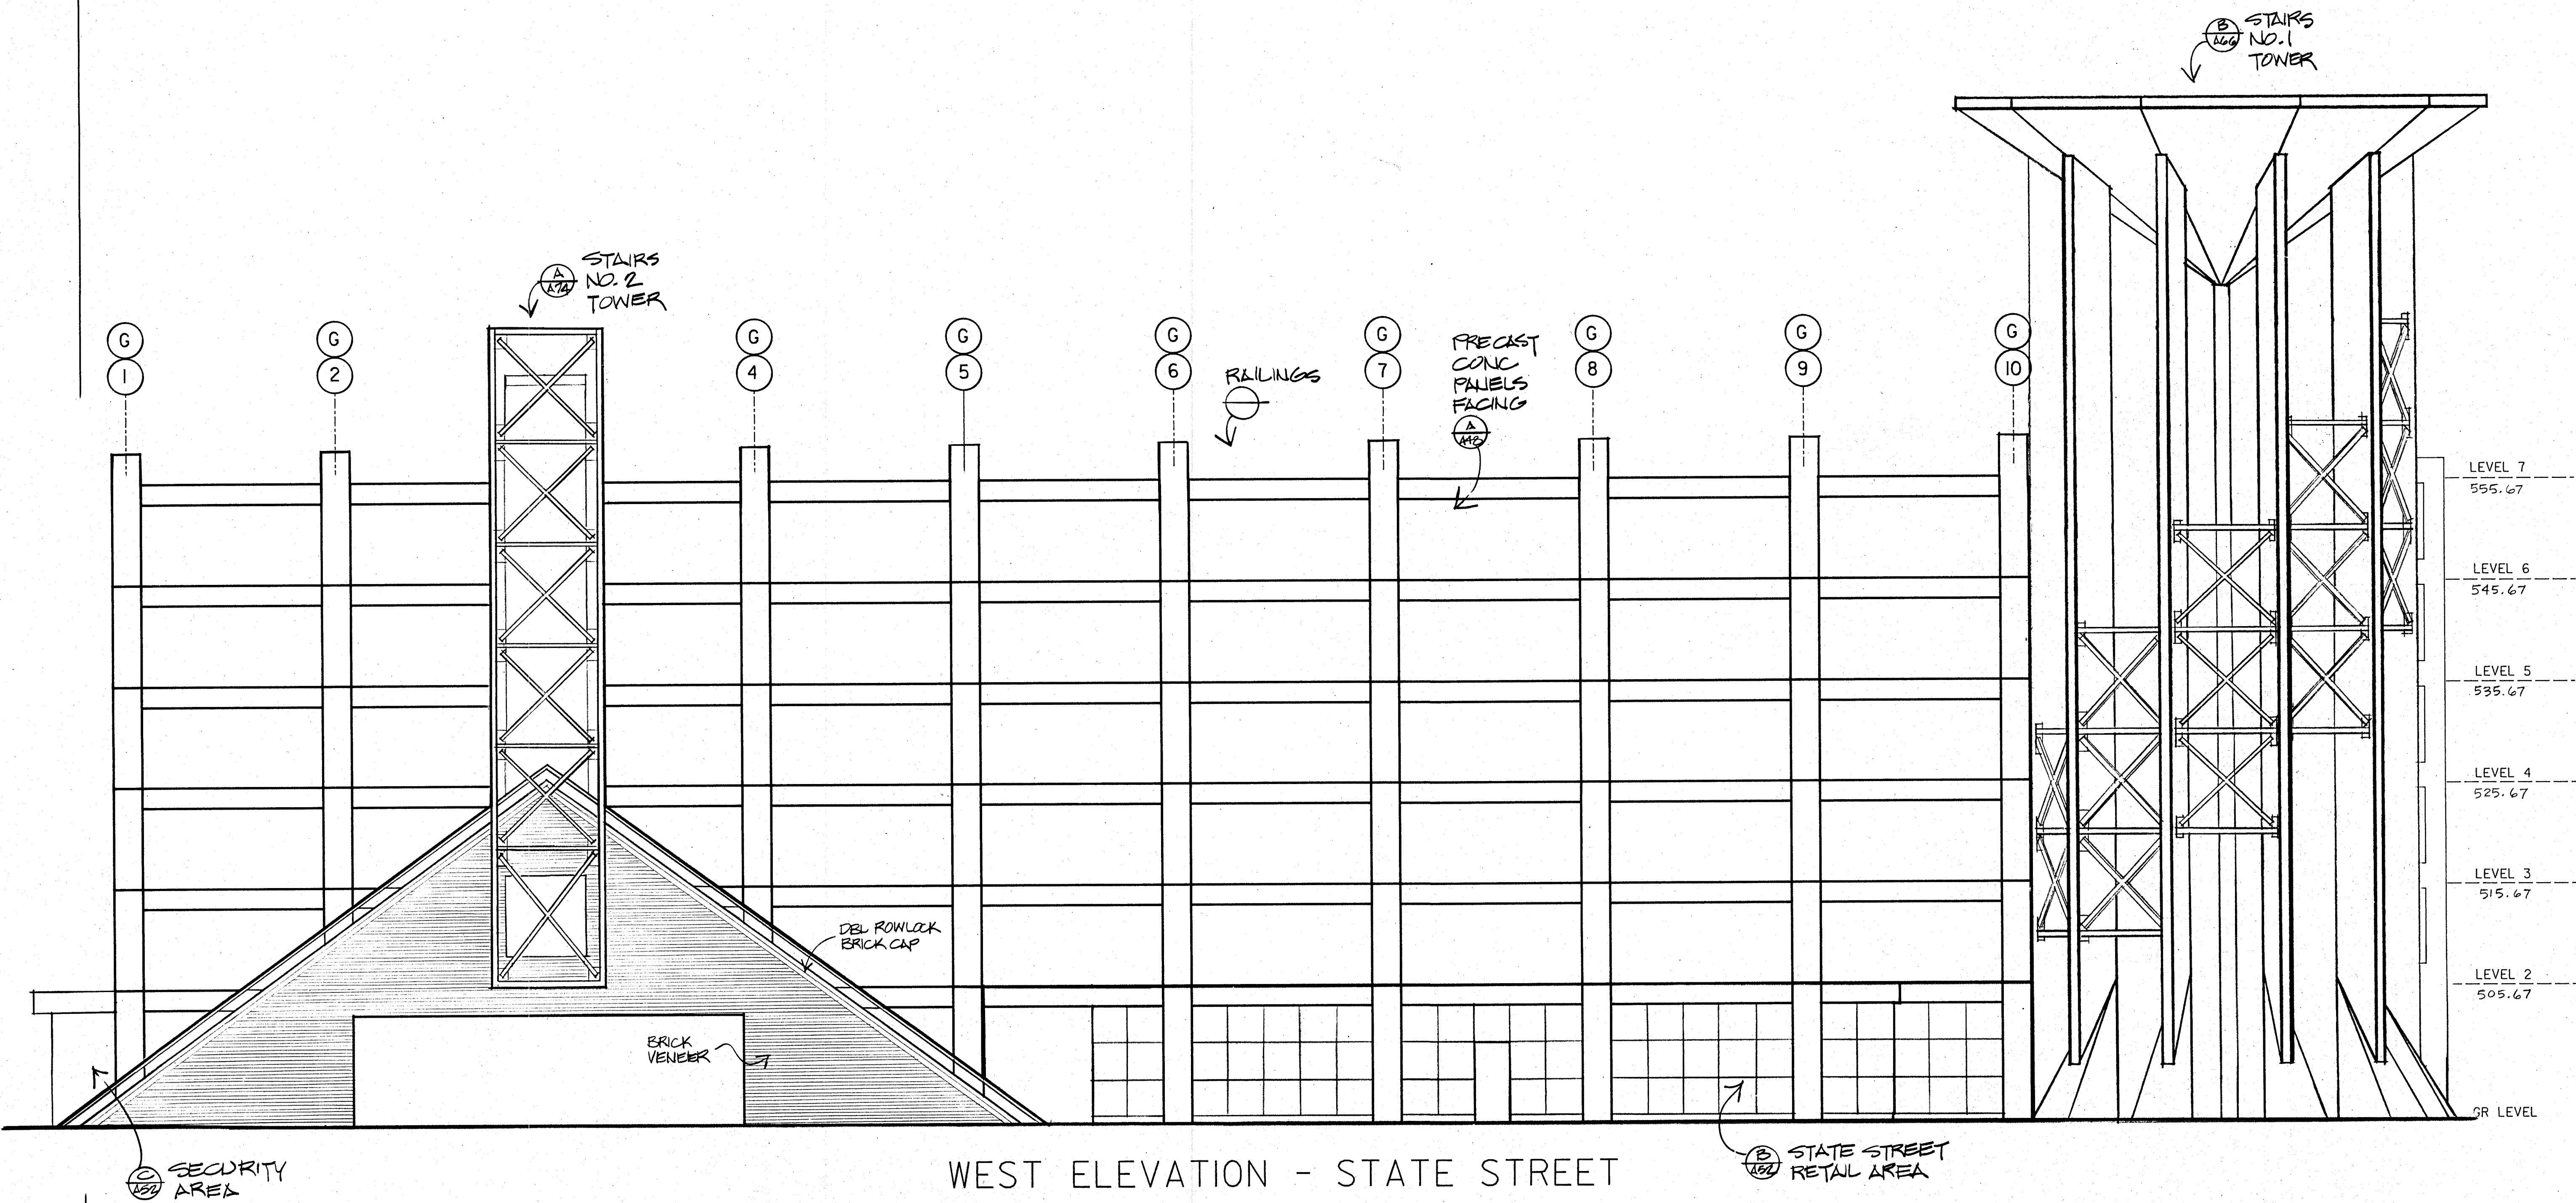

| NO. | REVISION | BY | DATE |
|-----|----------|----|------|
|     |          |    |      |
|     |          |    |      |
It is a violation of New York Education Law Article 15 Sec. 7209, for any person, unless he is acting under the direction of a licensed professional engineer or land surveyor, to offer or then in any way, if an item bearing the seal of an engineer or land surveyor is altered, the altering engineer or land surveyor shall be liable to the state and not liable to the state if followed by his signature and the date of such alteration, and a specific description of the alteration.

Copyright © 1992

**LABELLA**  
Engineering, Architecture and Surveying

LaBella Associates, P.C.  
300 STATE STREET  
ROCHESTER, N.Y. 14604  
(716) 454-680

STATE OF NEW YORK  
ROBERT A. JENNY  
REGISTERED ARCHITECT  
017606-1

BY: *[Signature]*  
LIC. NO. 017606-1 DATE: 8-12-92


CLIENT  
CITY OF ROCHESTER  
NEW YORK  
DEPARTMENT OF  
ENVIRONMENTAL  
SERVICES  
BUREAU OF  
MUNICIPAL FACILITIES

PROJECT NAME  
BROWN'S RACE  
PARKING GARAGE  
CITY OF ROCHESTER  
NEW YORK

DRAWING TITLE  
WEST  
ELEVATION

DESIGNED BY:  
DRAWN BY:  
CHECKED BY: LEB  
APPROVED BY: RAH

FIELD BOOKS PROJECT NO.  
91416  
SCALE: 1/8" = 1'-0" DWG. NO.  
DATE: 12 AUG 92 **A3-2**  
FILE NO. SHEET OF

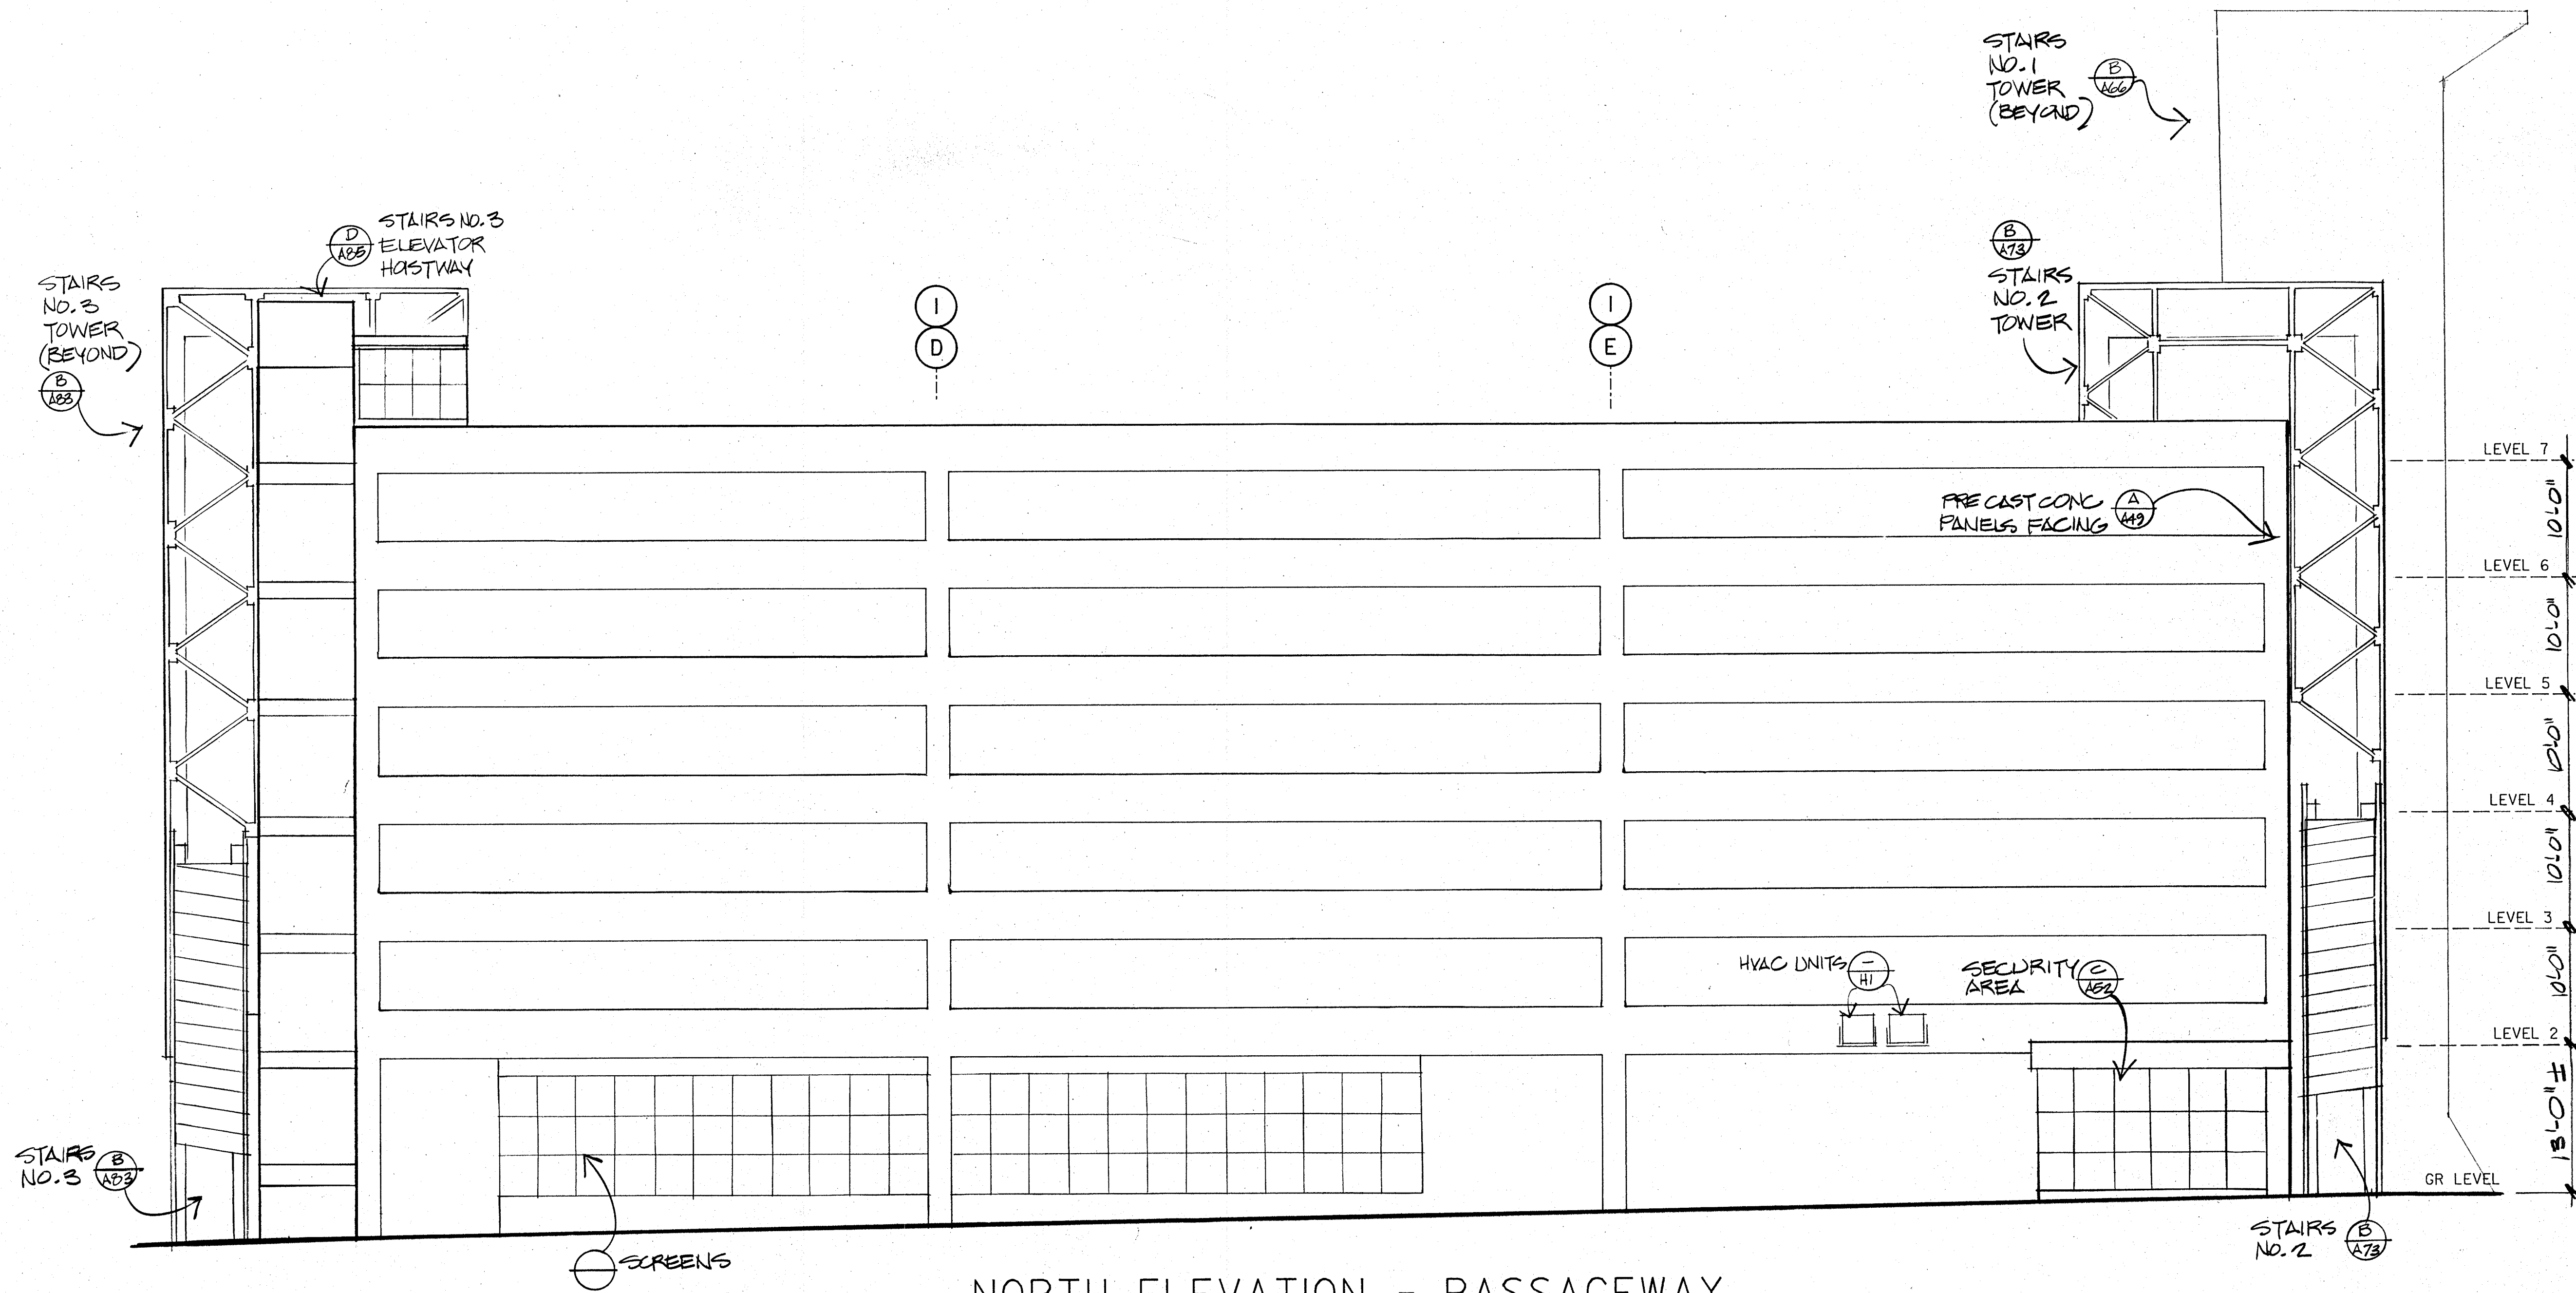

NORTH ELEVATION - PASSAGEWAY

| NO. | REVISION | BY | DATE |
|-----|----------|----|------|
|     |          |    |      |
|     |          |    |      |
It is a violation of New York Education Law Article 16 Sec. 120b, for any person, unless he is acting under the direction of a licensed professional engineer or land surveyor, to alter, on item in any way, if an item bearing the seal of an engineer or land surveyor is altered, the altering engineer or land surveyor shall affix to the item his seal and notation "altered by" followed by his signature and the date of such alteration, and a specific description of the alteration.

Copyright © 1992

**LaBella**  
Engineering, Architecture and Surveying

LaBella Associates, P.C.

300 STATE STREET  
ROCHESTER, N.Y. 14604  
(716) 454-6800



BY: *[Signature]*  
LISC. NO. 017608-1 DATE: 8-12-92

CLIENT  
**CITY OF ROCHESTER  
NEW YORK**  
**DEPARTMENT OF  
ENVIRONMENTAL  
SERVICES**  
**BUREAU OF  
MUNICIPAL FACILITIES**

PROJECT NAME  
**BROWN'S RACE  
PARKING GARAGE**  
**CITY OF ROCHESTER  
NEW YORK**

DRAWING TITLE  
**NORTH  
ELEVATION**

|                     |             |
|---------------------|-------------|
| DESIGNED BY:        | PROJECT NO. |
| DRAWN BY:           | 91416       |
| CHECKED BY: LEB     | DWG. NO.    |
| APPROVED BY: RAH    | <b>A3-3</b> |
| FIELD BOOKS         | SHEET OF    |
| SCALE: 1/8" = 1'-0" |             |
| DATE: 12 AUG 92     |             |
| FILE NO.            |             |





It is a violation of the New York Education Law, Article 145 Sec. 7209, for any person, unless he is acting under the direction of a licensed professional engineer or land surveyor, to alter an item in any way. If an item bearing the seal of an engineer or land surveyor is altered, the altering engineer or land surveyor shall affix to the item his seal and the notation "altered by" followed by his signature and the date of such alteration, and a specific description of the alteration.

**LABELLA**  
Engineering, Architecture and Surveying

**CLIENT**

**CITY OF ROCHESTER  
NEW YORK**

**DEPARTMENT OF  
ENVIRONMENTAL  
SERVICES**

**BUREAU OF  
MUNICIPAL FACILITIES**

**CROSS SECTIONS**

|                     |                          |
|---------------------|--------------------------|
| DESIGNED BY:        |                          |
| DRAWN BY:           |                          |
| CHECKED BY: LEB     |                          |
| APPROVED BY: RAH    |                          |
| FIELD BOOKS         | PROJECT NO.<br><br>91416 |
| SCALE: 1/8" = 1'-0" | DWSG. NO.                |
| DATE: 12 AUG 92     | <b>A4-2</b>              |
| FILE NO.            | SHEET OF                 |

