
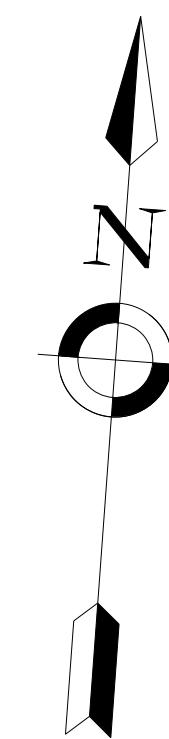


MATCH LINE TO DWG. NO. C 2.2

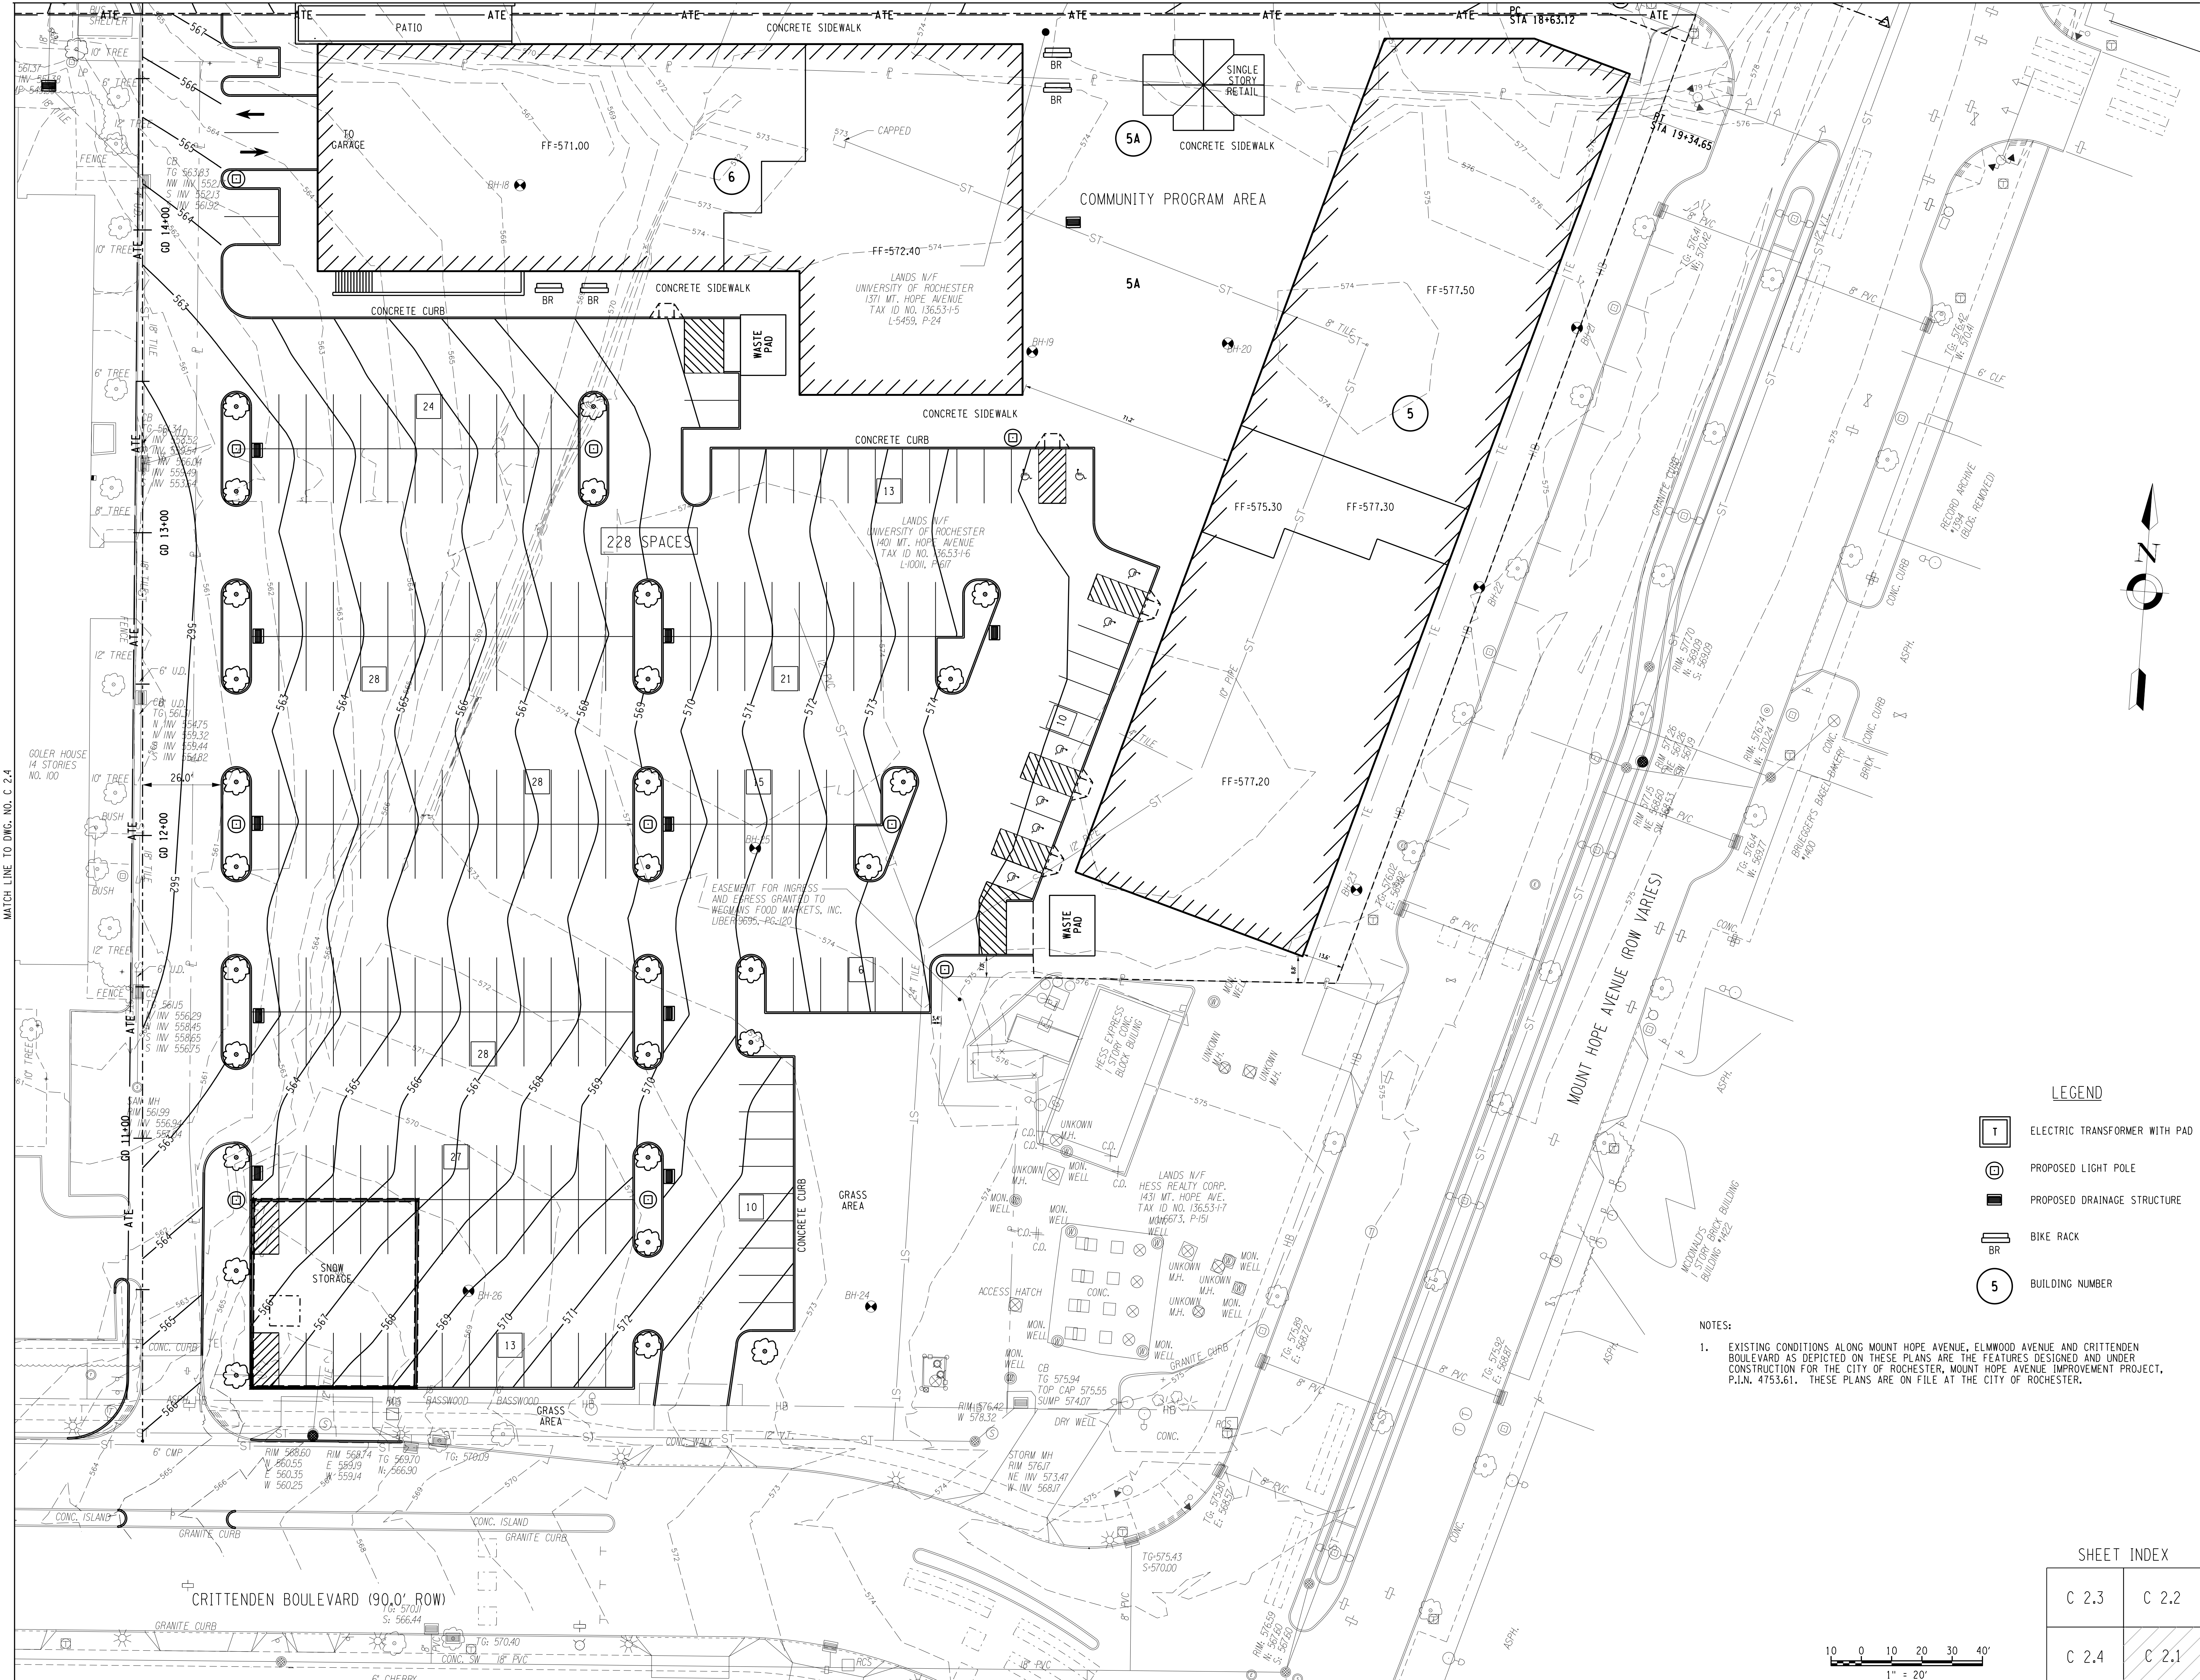

LEGEND


- T ELECTRIC TRANSFORMER WITH PAD
- ⊕ PROPOSED LIGHT POLE
- PROPOSED DRAINAGE STRUCTURE
- BR BIKE RACK
- 5 BUILDING NUMBER

NOTES:

1. EXISTING CONDITIONS ALONG MOUNT HOPE AVENUE, ELMWOOD AVENUE AND CRITTENDEN BOULEVARD AS DEPICTED ON THESE PLANS ARE THE FEATURES DESIGNED AND UNDER CONSTRUCTION FOR THE CITY OF ROCHESTER, MOUNT HOPE AVENUE IMPROVEMENT PROJECT, P.I.N. 4753.61. THESE PLANS ARE ON FILE AT THE CITY OF ROCHESTER.

SHEET INDEX

C 2.3	C 2.2
C 2.4	C 2.1

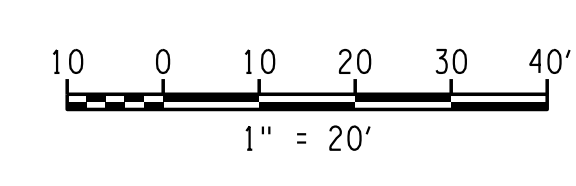

dcs
DESIGN

DAVIS
CARTER
SCOTT Inc.

Architecture
Interior Architecture
Landscape Planning
Surveying
1676 International Drive
Suite 300
McLean, Virginia 22102
P: 703.556.9275
F: 703.821.8976
www.dcsdesign.com

LABELLA
Associates, P.C.

Relationships. Resources. Results.

www.labellapc.com
300 STATE STREET
ROCHESTER, NY 14614
P: (585) 454-6110
F: (585) 454-3066

Engineering
Architecture
Environmental
Planning

PROJECT CLIENT

COLLEGETOWN OF ROCHESTER PROJECT

NO.	DATE	REVISION

ISSUED FOR
PRELIMINARY SITE PLAN REVIEW
DRAWING TITLE
GENERAL PLAN

DATE: JULY 2012

SCALE: 1" = 20'

DESIGNED BY: CAE

DRAWN BY: SRM

REVIEWED BY: W D

PROJECT NUMBER: 212462

DRAWING NUMBER

C 2.1

PLOTTER: HP DesignJet 2450
 PLOT DATE: 7/25/12 10:00 AM
 PLOT TIME: 0:00:00
 PLOT SCALE: 1" = 20'
 PLOT SHEET: C 2.1